



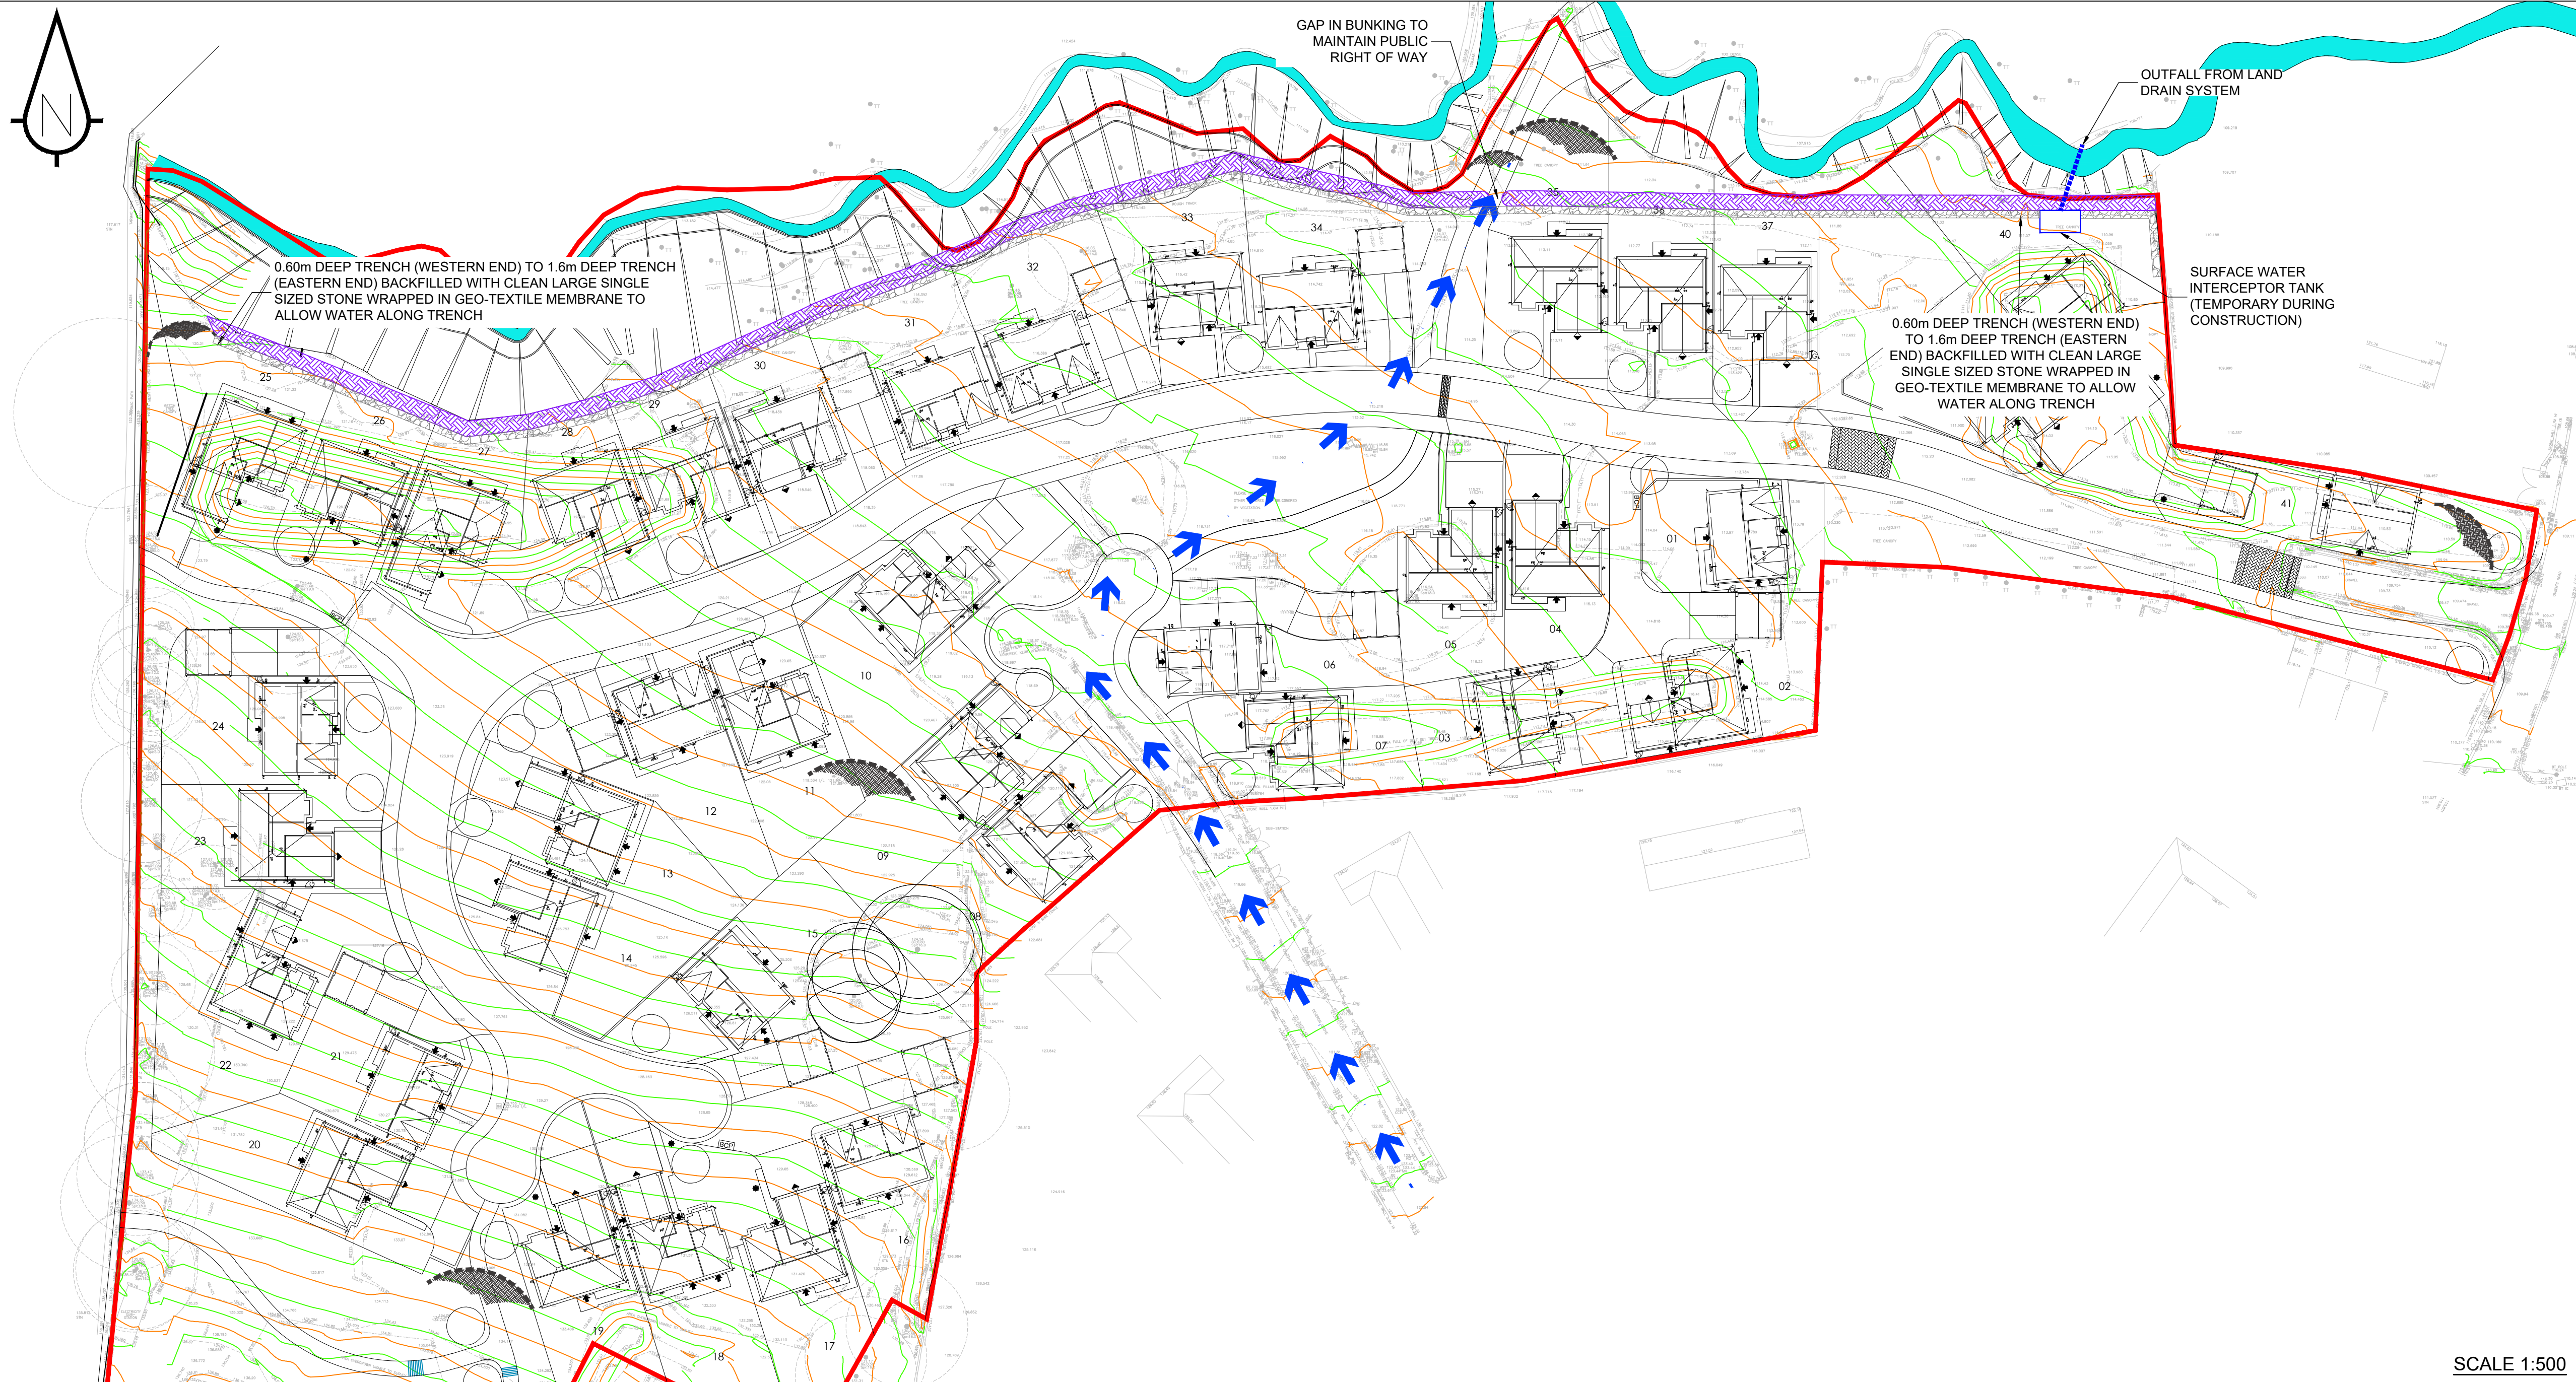


- Sanderson Associates Consulting Engineers ("the consultant"), has not checked or verified, and shall have no liability whatsoever for any inaccuracies which may be attributable to any data, reports, base plan(s) and drawings provided by the client, or purchased by the consultant on the client's behalf, that may have been utilised within this drawing.
- The consultant shall not be liable for the use by any person of any document for any purpose other than that for which the same were provided by the consultant.
 - No liability whatsoever is accepted by the consultant for any error or omissions.
 - The consultant accepts no liability for any vehicle specification errors within the vehicle track software used and / or it's vehicle libraries.
 - The locations of utilities apparatus, if shown, is reproduced from plans supplied to the consultant, although care has been taken when duplicating this information. These locations are approximate only and no guarantee can be given for their accuracy. It is the client's or it's appointed agent/contractors responsibility to verify the exact locations on site by hand dug trial holes or other appropriate means prior to mechanical excavation.
 - Service connections are not shown but their presence should be anticipated.
 - Reference to any third party equipment shown on this drawing was only relevant at the time the drawing was prepared.
 - It is the client's responsibility to ensure that any equipment ordered meets the design.
- KEY:**
- BUND WITH WATER CHANNEL
 - TRENCH BACKFILLED WITH CLEAN LARGE SINGLE SIZED STONE WRAPPED IN GEO-TEXTILE MEMBRANE TO ALLOW WATER ALONG TRENCH
 - Ø300mm DRAIN
 - DIRECTION OF FLOW OF OVERLAND WATER
 - PROPOSED HY-TEX TERRASTOP PREMIUM SILT FENCE TO BE INSTALLED STRICTLY IN ACCORDANCE WITH MANUFACTURERS DETAILS
 - EXISTING MAJOR CONTOURS
 - EXISTING MINOR CONTOURS


SCALE 1:500

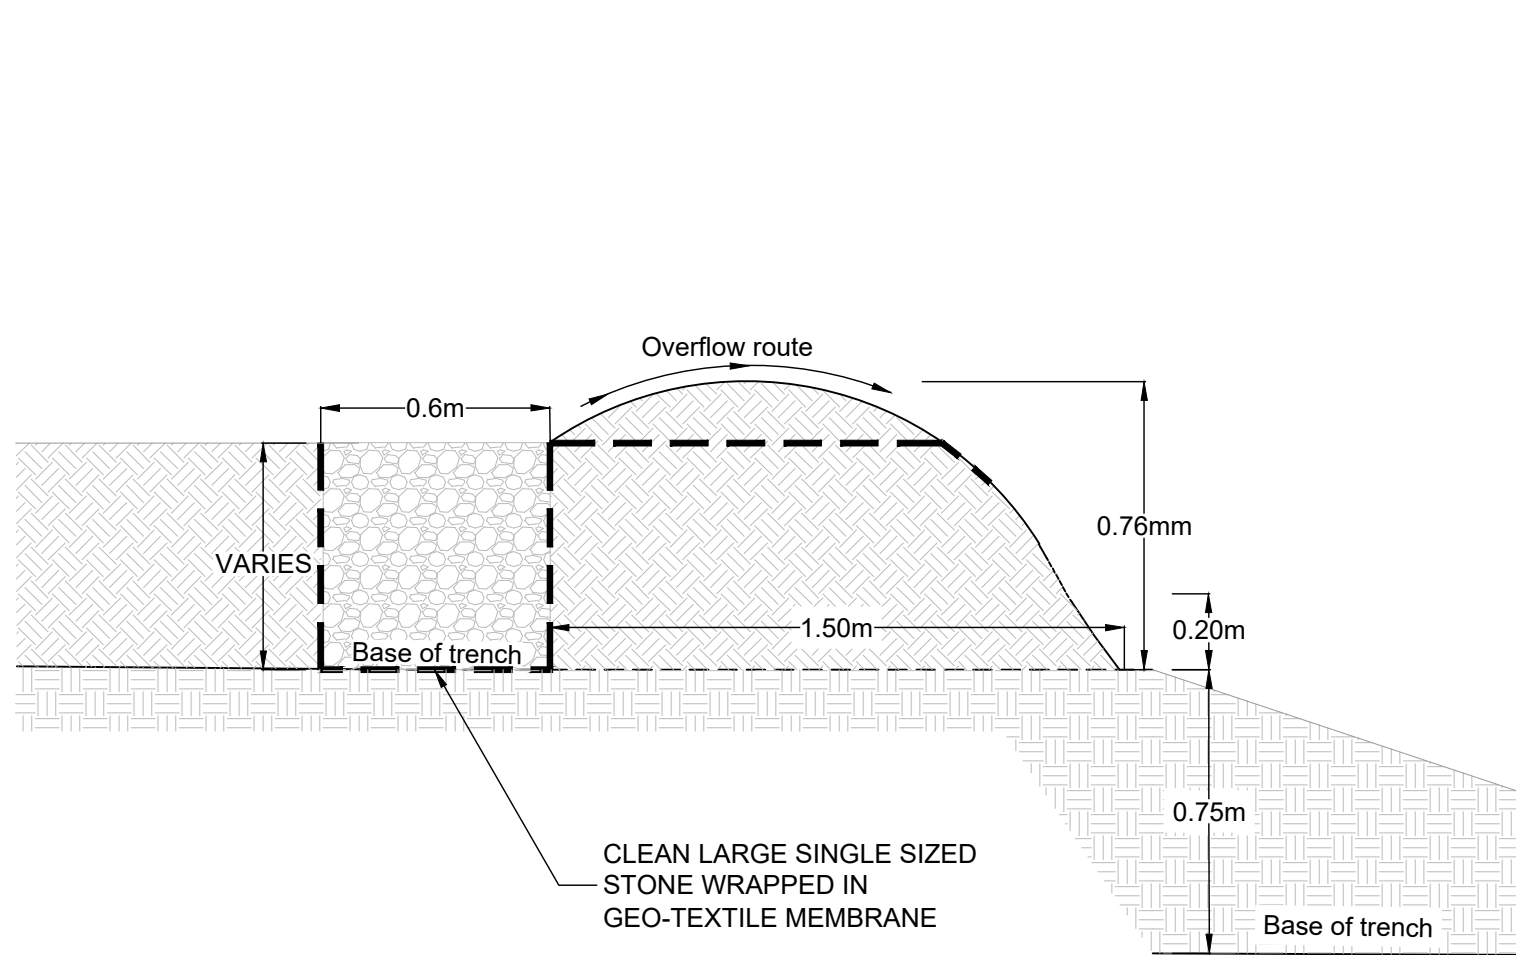

SECTION THROUGH PROPOSED SURFACE WATER LAND DRAIN
Scale 1:20

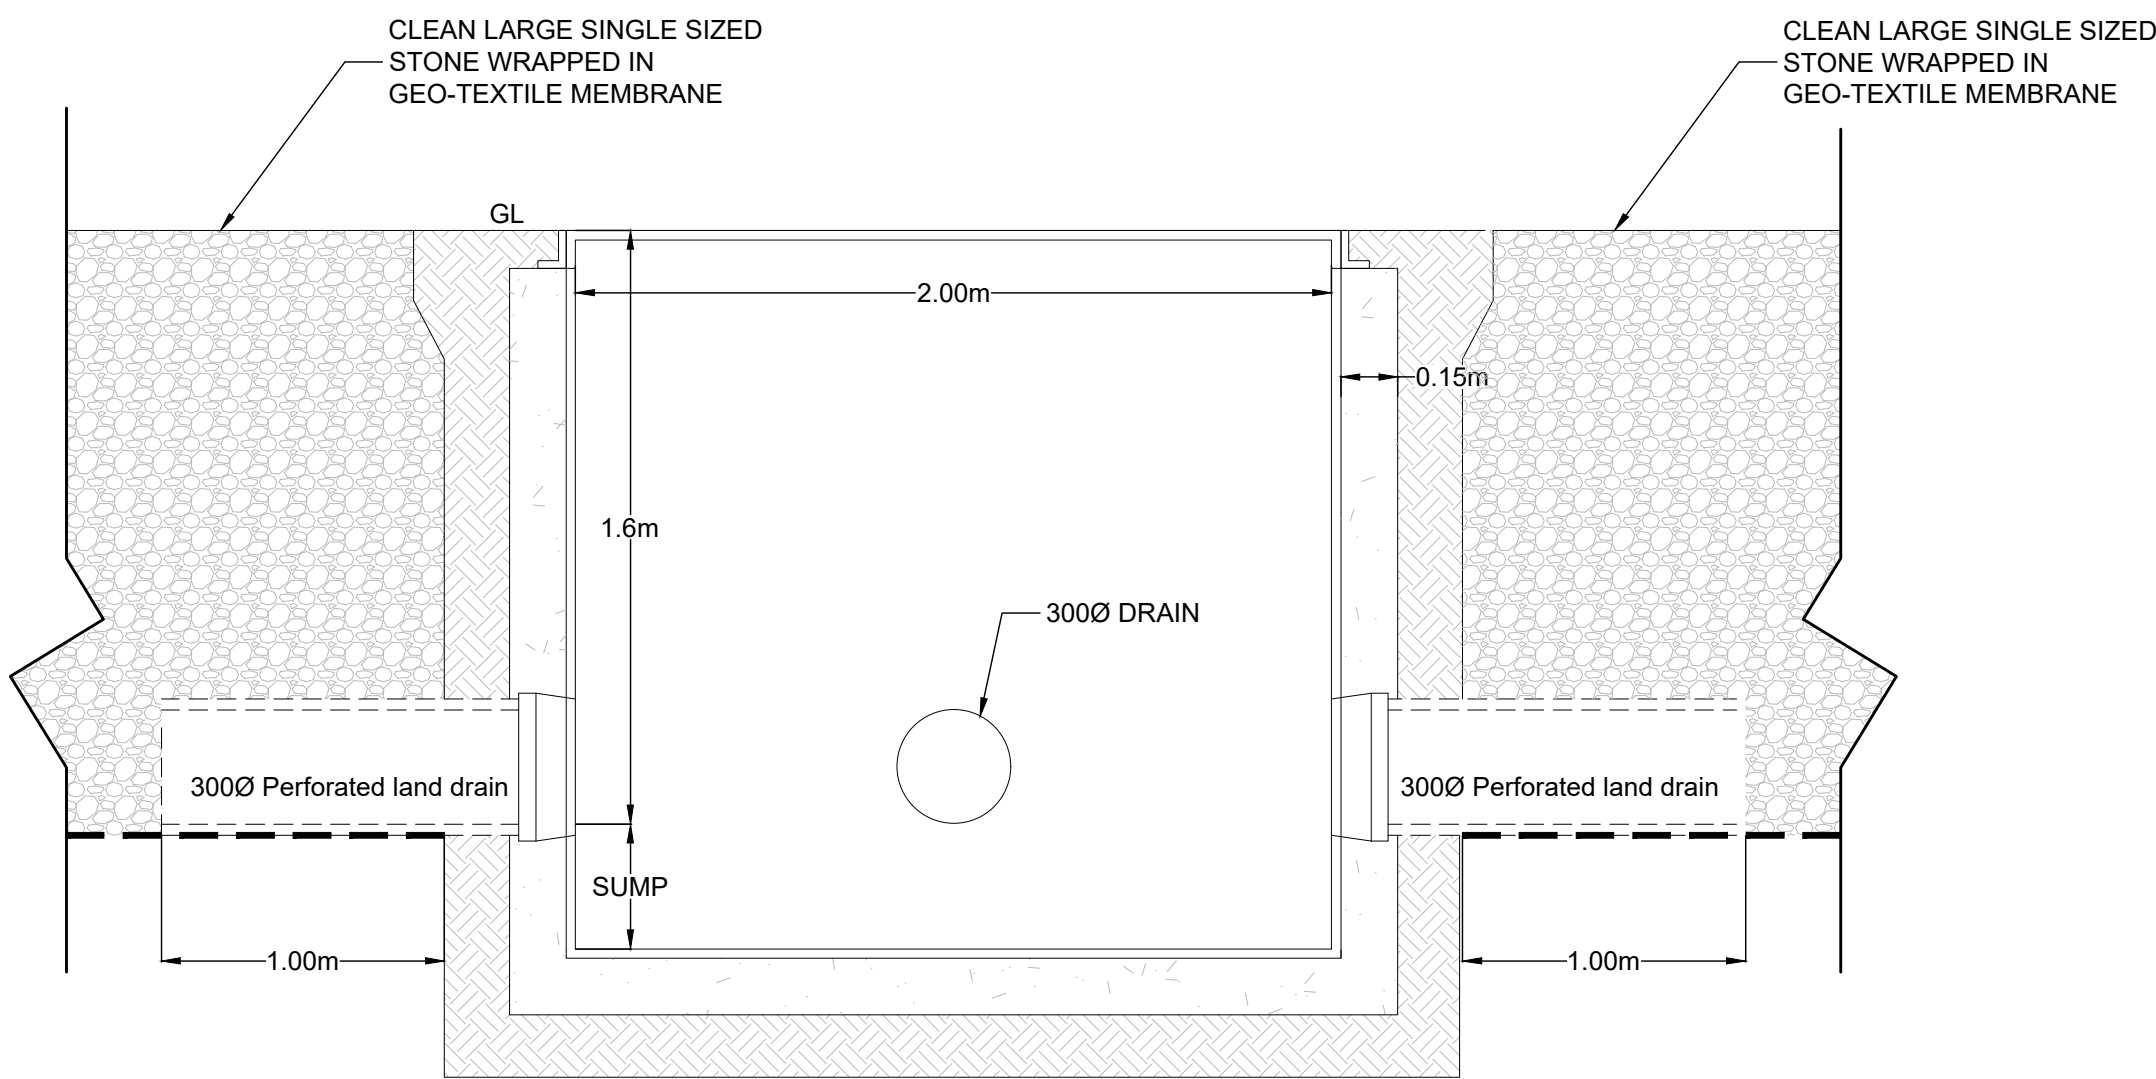

SURFACE WATER INFILTRATION TANK
Scale 1:20

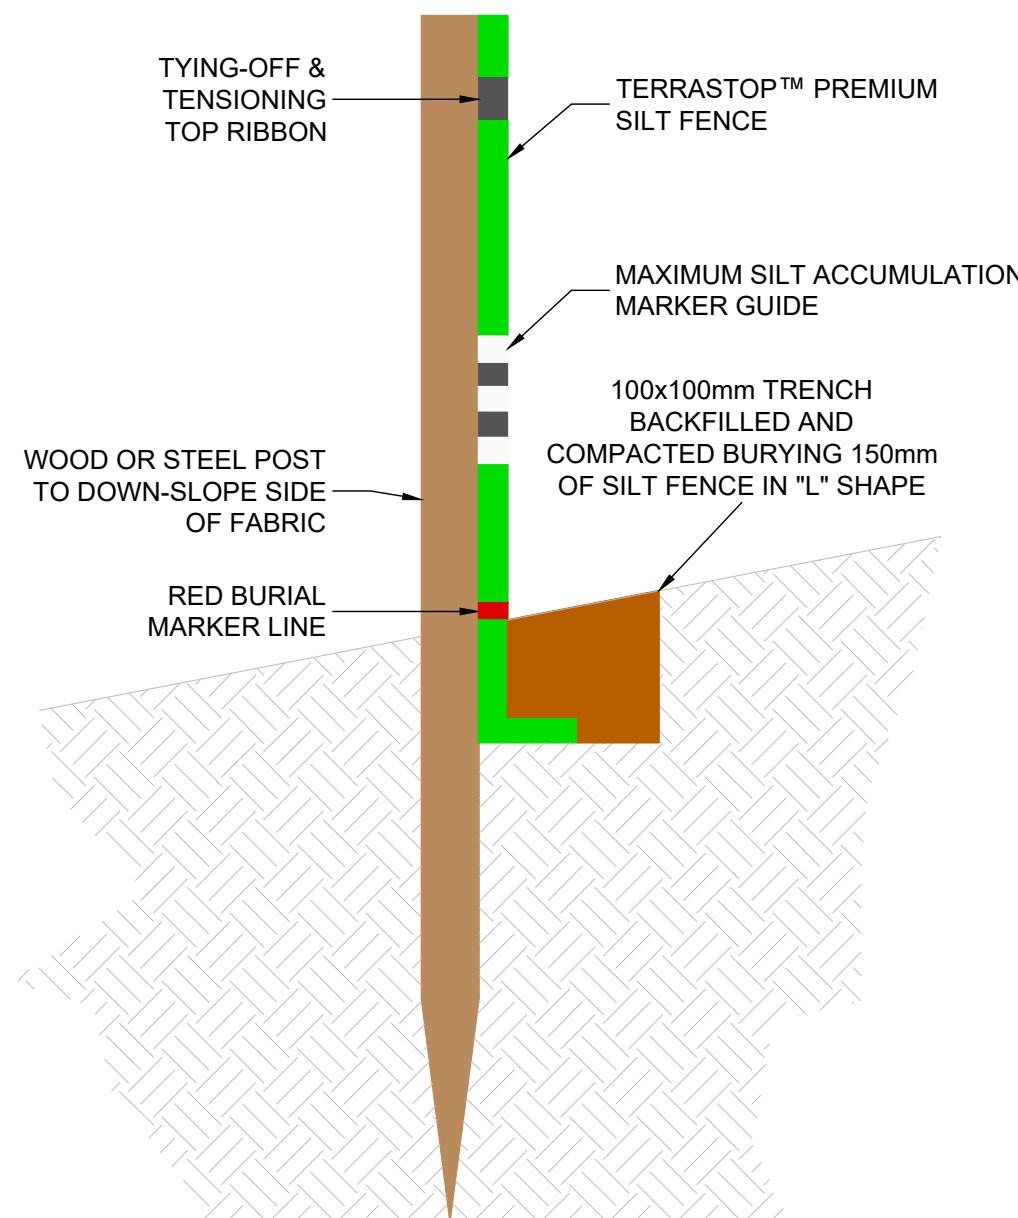

HY-TEX TERRASTOP PREMIUM SILT FENCE SECTION
Not to Scale

P03	DRAINAGE LAYOUT AMENDED FOLLOWING CLIENT COMMENTS 26/03/2025	TC	28/03/2025	DB
P02	SILT FENCING ADDED	TOD	13/12/2024	TC
P01	FIRST ISSUE	TOD	10/09/2024	TC
Rev	Amendment	Drawn	Date	Checked

Drawing Status

S3 - FOR COMMENT



Client

JONES HOMES (YORKSHIRE) LTD

Project Title

SECTION 38
CLAYTON MANOR

Drawing Title

TEMPORARY DRAINAGE
ARRANGEMENT

Scale	Drawing Size	Drawn By	Checked By
AS STATED	A1	TOD	TC
Project Number	Date	Approved By	
163366	OCTOBER 2024	TC	
Drawing Number	Rev		
163366-SAN-CLF-CC-DR-C-05_101	P03		

UNTIL TECHNICAL APPROVAL HAS BEEN OBTAINED FROM THE RELEVANT LOCAL AUTHORITIES OR STATUTORY BODIES, IT SHOULD BE UNDERSTOOD THAT ALL DRAWINGS ARE ISSUED AS PRELIMINARY AND NOT FOR CONSTRUCTION. SHOULD THE CONTRACTOR AND / OR EMPLOYER COMMENCE WORK PRIOR TO APPROVAL BEING GIVEN, IT IS ENTIRELY AT THEIR OWN RISK