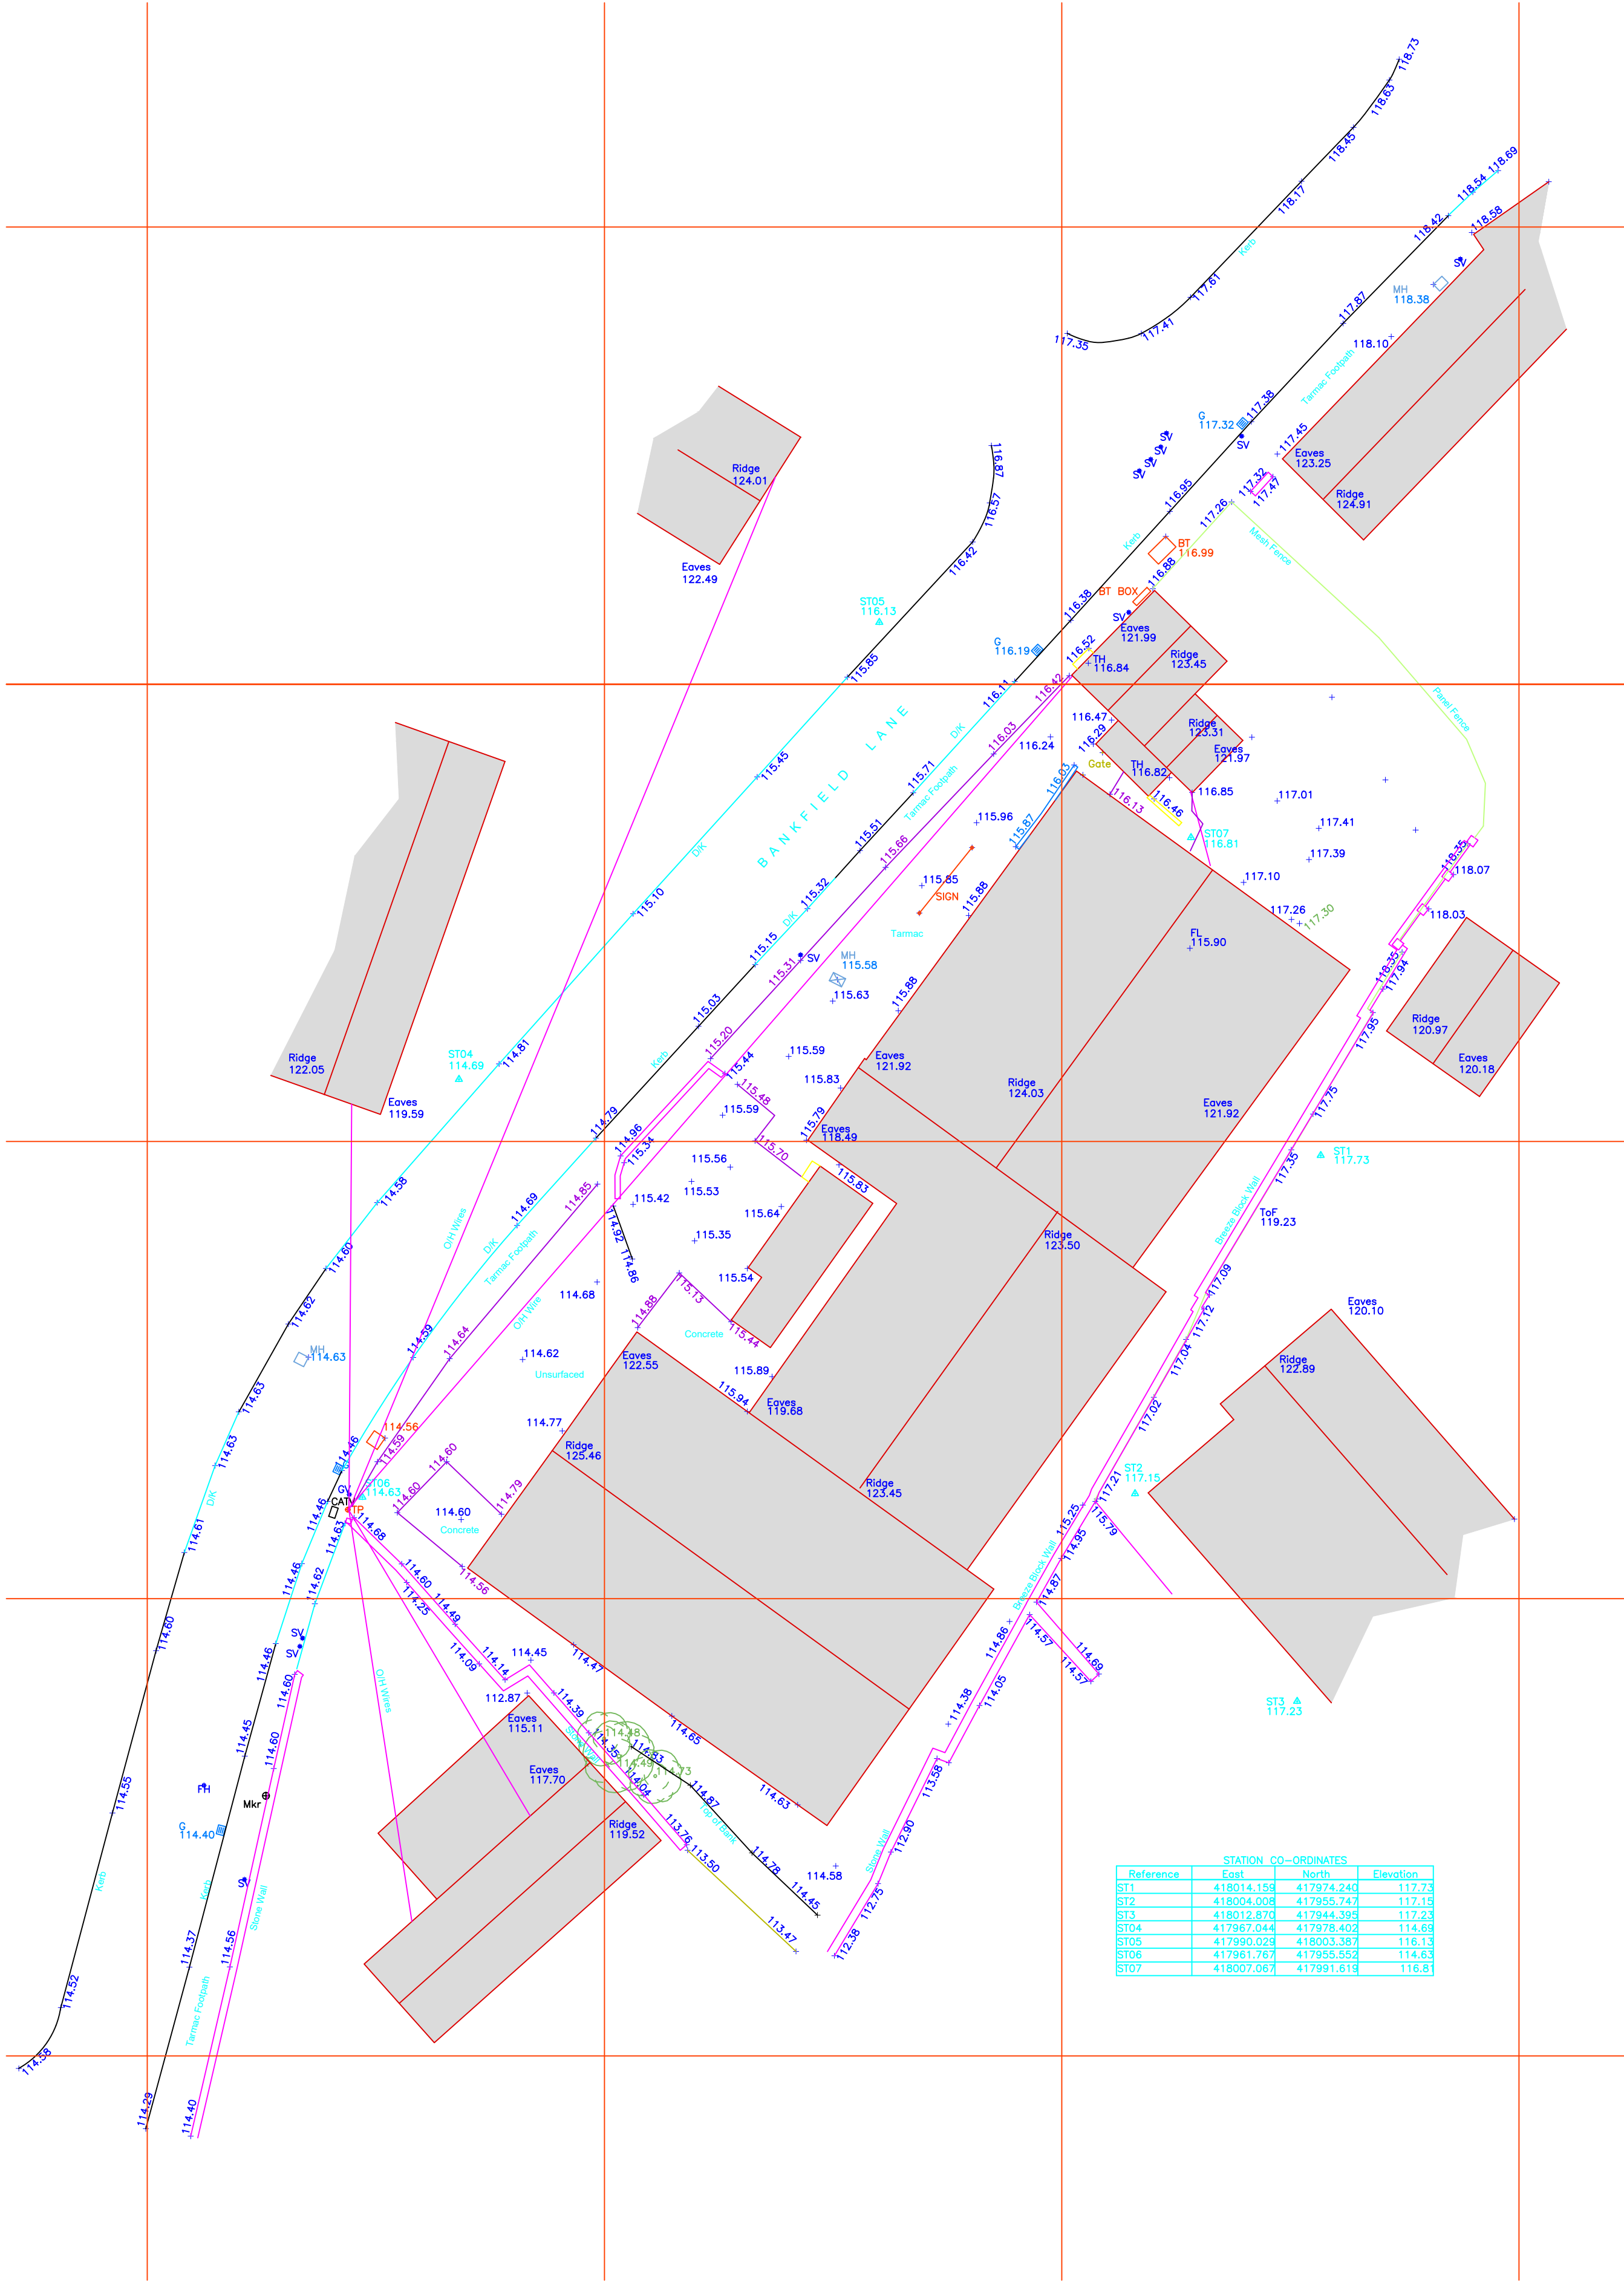


Abbreviation & Symbol Key.

B	Bollard	RSC	Rollod Steel Joist
BB	Bellish Beacon	RSJ	Rollod Steel Joist
BT	British Telecom Cover	RWP	Rain Water Pipe
BM	Bench Mark	SC	Stop Cock
CL	Cover Level	SP	Sign Post
DK	Drop Kerb	STP	Stand Pipe
EL	Electricity Cover	SV	Stop Valve
EP	Electricity Pole	SVP	Soil Vent Pipe
FH	Fire Hydrant	SWG	Storm Water Gully
FFP	Flagged Footpath	SW	Storm water
G	Gully	TTP	Tarmac Footpath
GM	Gas Meter	TL	Traffic Light
GV	Gas Valve	TP	Unable To Lift
IC	Inspection Cover	UTL	Telegraph Pole
IL	Invert Level	VP	Vent Pipe
LB	Lamp Post	WM	Water Meter
LP	Lamp Post	WP	Waste Pipe
MB	Multi Bole		
M4	Man Hole	Fences & Walls	
Mv	Marker Post	Ret	Retaining Wall
MS	Mile Stone	BW	Barbed Wire
MT	Mercury Telecommunications	CB	Close Boarded
NB	Noise Board	C/I	Compacted Iron
NFI	No Further Information	OL	Chain Link
OSBM	Ordnance Survey BM	CIP	Chain Link
P	Post	IR	Iron Railing
PB	Post Box	Lat	Lattice
RE	Roading Eye	P/C	Post & Chain
RL	Rootline	P/R	Post & Rail
RS	Road Sign	P/W	Post & Wire
SS	Street Name Sign		
		Trees	
		0.25/10/10/Syc	
		Diameter/Height/Spread/Species	

General
Details or services hidden or obscured by vegetation, debris or vehicles at survey dates may be omitted. Hedge & Vegetation details are outline

Control & Datum Information

Grid - Station ST1 Coordinates are OS GPS RTK
All other Stations are relative to this in Plane Grid Projection and Grid North

Datum - OS Level Datum.
Using OS GPS RTK Network

OS Grid @25m to cover Site

Revision		Description	By		Date

Surv.	Drawn	Date	Chkd	Date	Appr'd	Date
GH/KH	GH	20/09/12	SH	21/09/12		

This drawing is the property of H&H Surveys. Copyright is reserved by them and the drawing is issued on the condition that it is not copied either wholly or in part without consent in writing of H&H Surveys. Figured dimensions to take preference over those scaled. All dimensions to be checked on site before commencement of any work or shop drawings. This drawing is to be read in conjunction with the specification when existing and all other consultants drawings.

Client.

Northern Design Partnership

Title. SITE PLAN

Site. Kirkheaton Engineering
Bankfield Road
Huddersfield



41 Brampton Crescent
Wombwell
Barnsley
Yorkshire S73 0SZ
Tel: 01226 734099 Fax: 01226 734102
Email: stephen@hhsurveys.co.uk

THIS IS A CAD DRAWING - DO NOT ALTER

Dwg No. NDP/318/SP

Sheet No.

SCALE	1/250	REV.	
-------	-------	------	--