


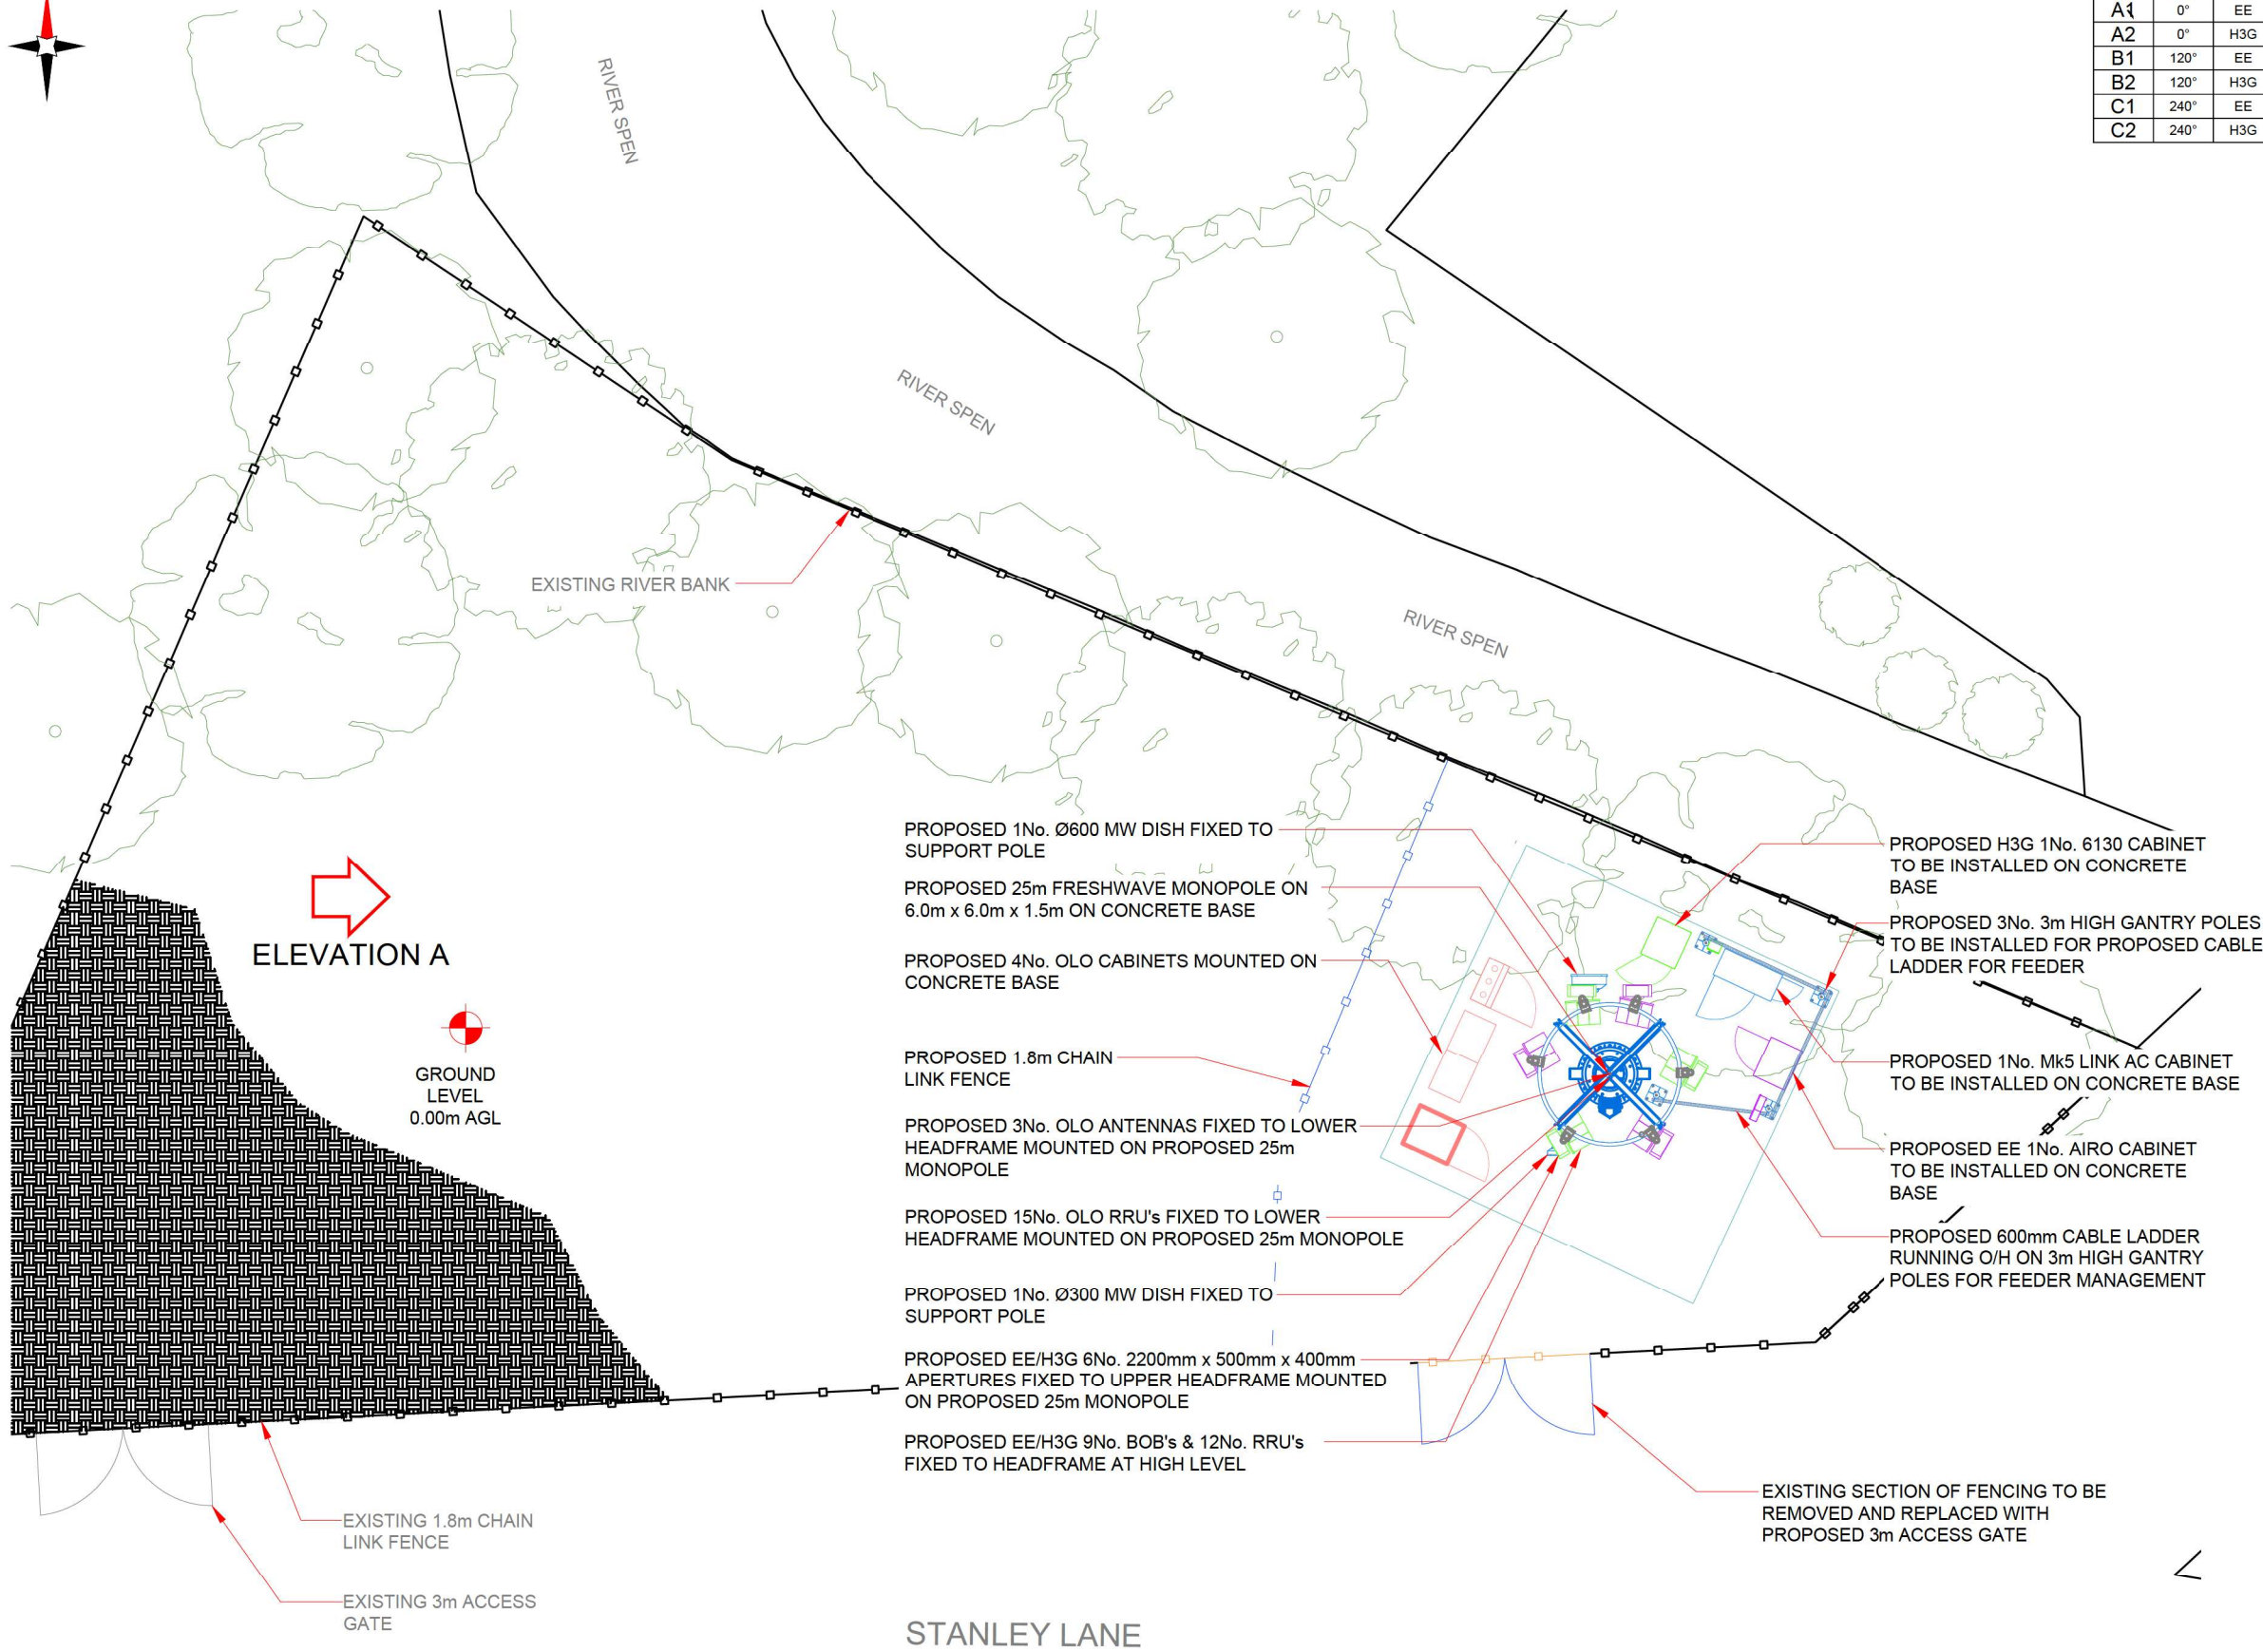

Antenna Aperture ID	Proposed 4G/5G Bearing	Operator: Shared/ EE/H3G
A1	0°	EE
A2	0°	H3G
B1	120°	EE
B2	120°	H3G
C1	240°	EE
C2	240°	H3G

NOTES:

1. ALL DIMENSIONS IN MM UNLESS OTHERWISE NOTED.

Master	MBNL / EE / H3G	Project:		Purpose of Issue:	Issue:
M002	MBNL	NTQ		Planning	B
Date:	28/02/2025	Revision / Upgrade Description:			
Drawn:	J.Miah	GA full pack added in			
Checked:	W.Jackson				
Approved:	W.Jackson				
Master	MBNL / EE / H3G	Project:		Purpose of Issue:	Issue:
M001	MBNL	NTQ		Planning	A
Date:	16/12/2024	Revision / Upgrade Description:			
Drawn:	J.Miah	First Issue			
Checked:	W.Jackson				
Approved:	W.Jackson				

	Hutchison 3G UK Limited Star House, 20 Grenfell Road Maidenhead, SL6 1EJH Tel: 01628 765 000 Fax: 01628 765 001		Hatchfield Business Park Hatchfield Hertfordshire AL10 9BW Tel: 01707 315000 Fax: 01707 319001
H3G Base Station Information line: 0845 0843000 Available 24/7 Monday to Friday			

MBNL Mobile Broadband Network Limited
Sixth Floor, Thames Tower, Station Road, Reading, RG1 1LX



FreshWave
You're on

Site Name: VICTORIA MILL

Site ID: 1738569

Address: VICTORIA MILL CARR STREET
WAKEFIELD
WEST YORKSHIRE
WF15 6EA

Title: 215 MAX CONFIGURATION SITE PLAN

Project: NTQ

Purpose of Issue: **GENERAL ARRANGEMENT**

EE Cell ID: 33495	MBNL Cell ID: KKS302	3UK Cell ID: WF1048
-----------------------------	--------------------------------	-------------------------------

Master Drawing No:	1738569_KKS302_33495_WF1048_M002	Issue:	B
--------------------	----------------------------------	--------	---

Passive Infrastructure Equipment Capacity & Lead Operator			
A	B	C	LEAD
S2a	S2a	S2a	EE