


General Notes

1. Do not scale this drawing.
2. All dimensions are in millimeters unless stated otherwise.
3. This drawing is to be read in conjunction with all other relevant drawings & specifications.
4. All proprietary items to be installed in strict compliance with manufacturers instructions and recommendations.
5. No works shall commence on site until approval has been obtained from all relevant Agencies / Authorities.
6. All dimensions referred to in this drawing must be verified.

Key

- Site Boundary
- Section 104 - Sewer Easement
- Section 104 - Surface Water Sewer
- Section 104 - Surface Water Manhole
- Section 104 - Foul Water Sewer
- Section 104 - Foul Water Manhole
- Section 104 - Combined Water Sewer
- Section 104 - Combined Water Manhole
- Yorkshire Water Combined Water Sewer
- Yorkshire Water Combined Water Manhole

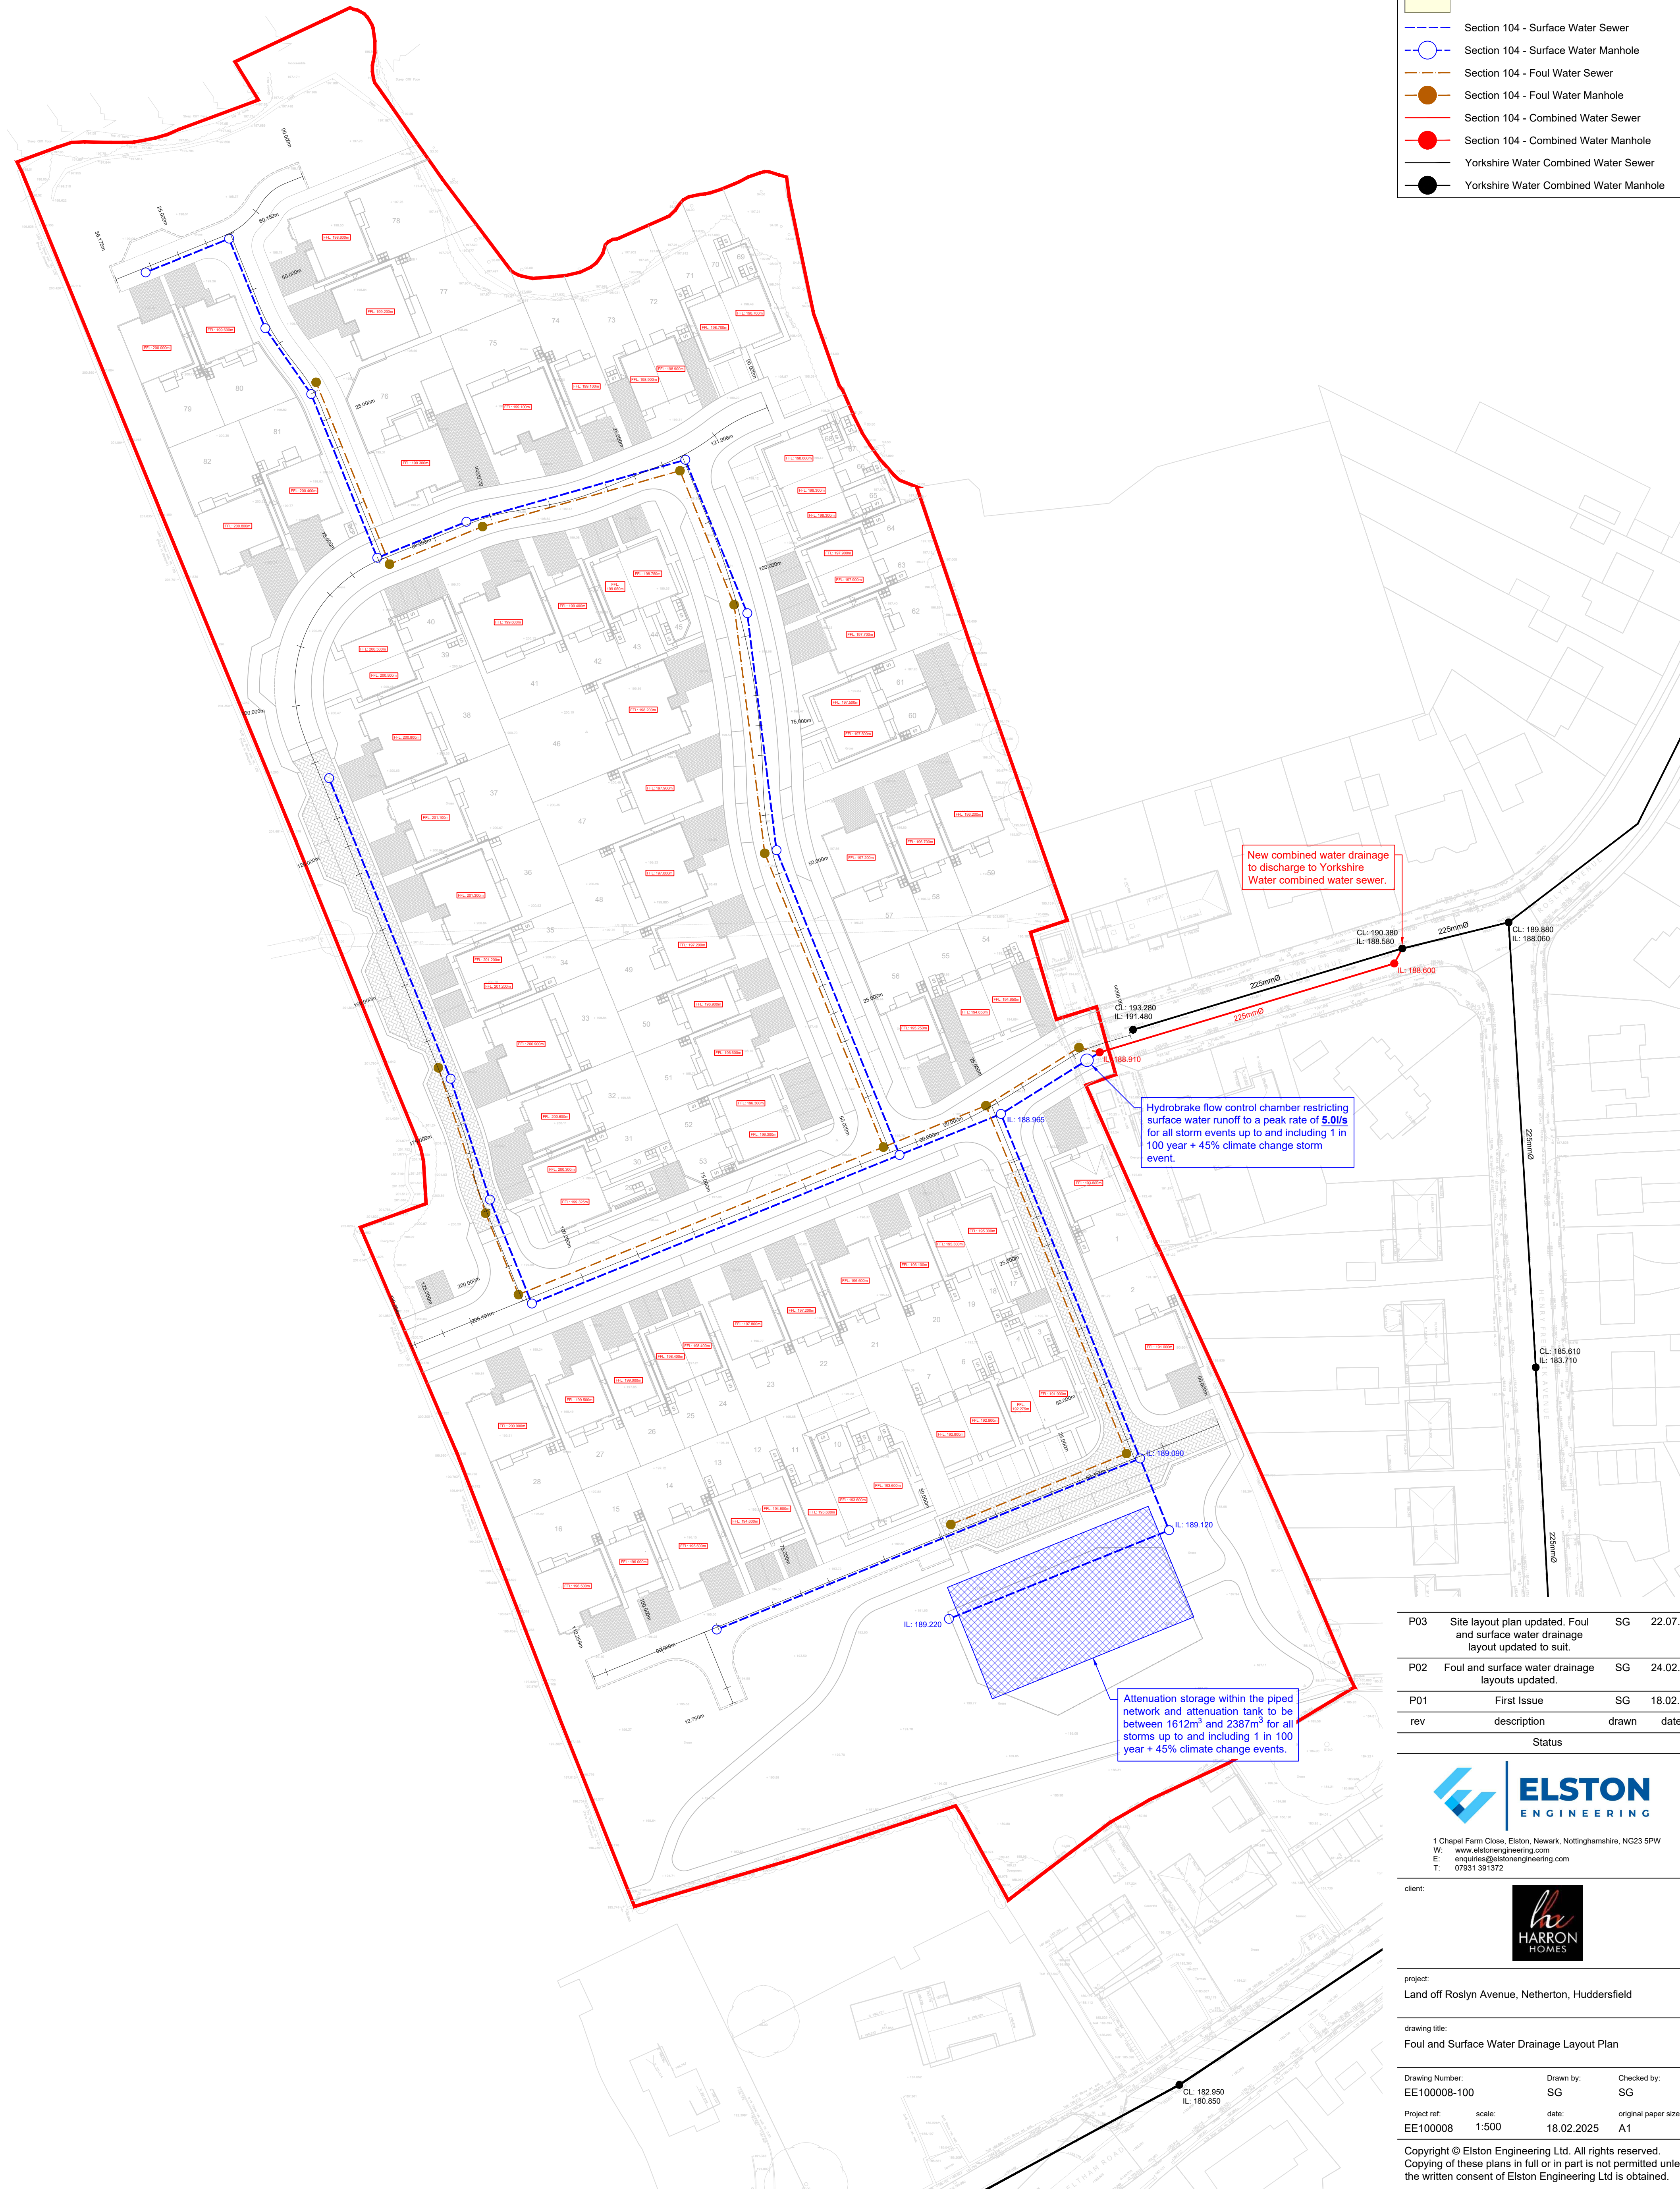

P03	Site layout plan updated. Foul and surface water drainage layout updated to suit.	SG	22.07.25
P02	Foul and surface water drainage layouts updated.	SG	24.02.25
P01	First Issue	SG	18.02.25
rev	description	drawn	date
Status			



1 Chapel Farm Close, Elston, Newark, Nottinghamshire, NG23 5PW
W: www.elstonengineering.com
E: enquiries@elstonengineering.com
T: 07931 391372

client:



project:
Land off Roslyn Avenue, Netherton, Huddersfield

drawing title:
Foul and Surface Water Drainage Layout Plan

Drawing Number: EE100008-100	Drawn by: SG	Checked by: SG
Project ref: EE100008	scale: 1:500	date: 18.02.2025
		original paper size: A1

Copyright © Elston Engineering Ltd. All rights reserved.
Copying of these plans in full or in part is not permitted unless the written consent of Elston Engineering Ltd is obtained.