


NOTES


Streetlamp posts should be aligned with parking lines
PSU parking stalls are 275cm wide.

For further details please refer to PSU Metal Post
Installation Guide


The handles of the stalls to
be at the centre of the bays

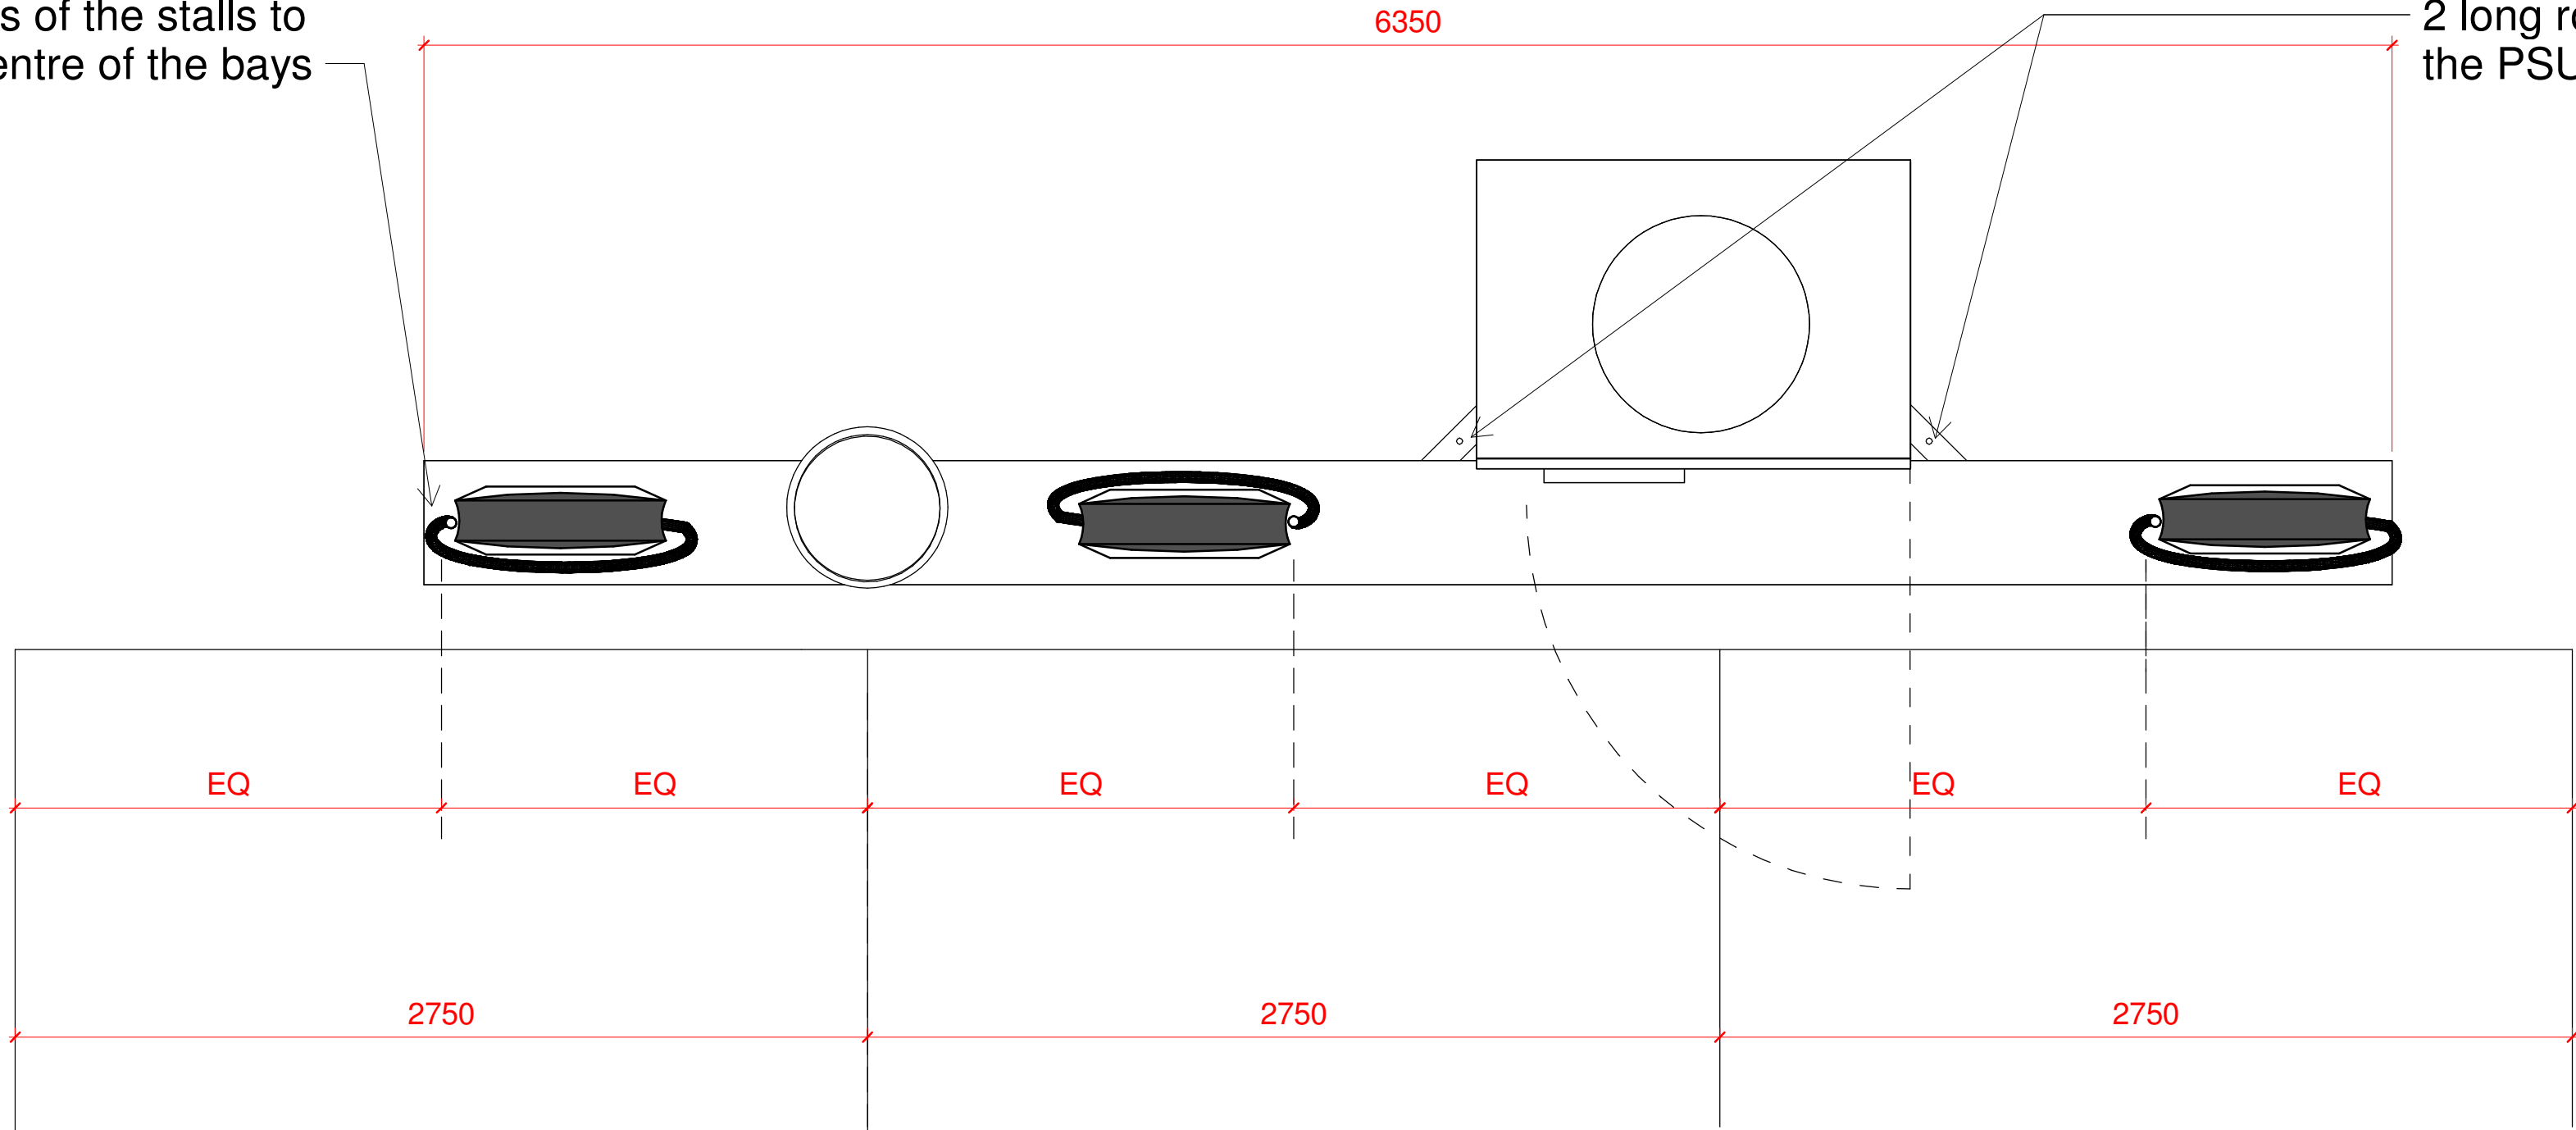

Pre-Installed PSU Metal 3 post unit
1 : 20

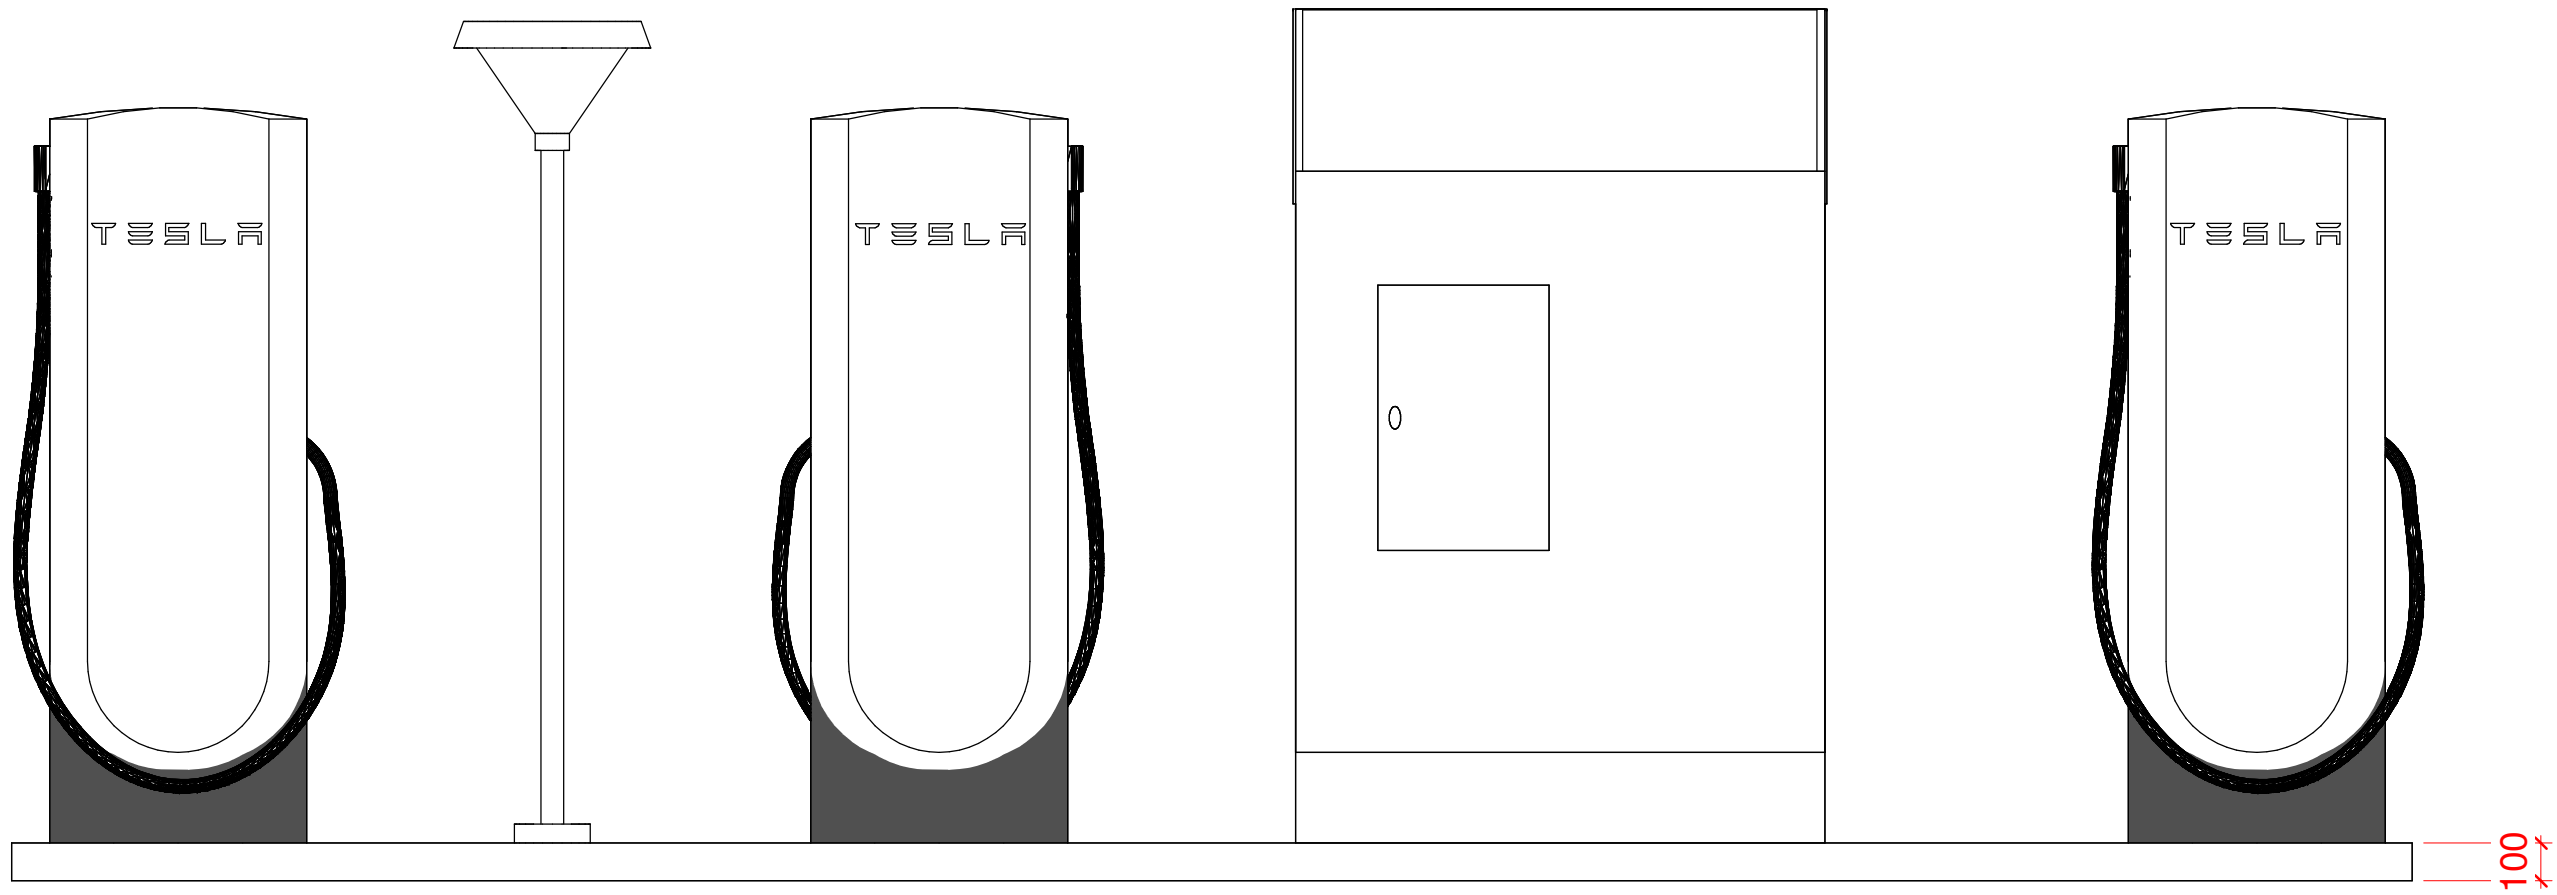

Pre-Installed PSU Metal 3 post unit - Front Elevation
1 : 20

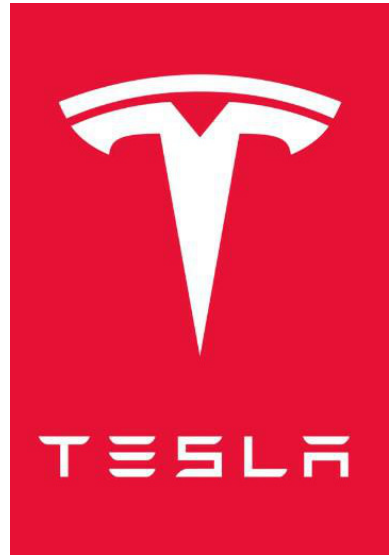

Leeds Birstall SUC Site

Gelderd Road, Birstall,
Batley, WF17 9TB

ISSUE / REVISIONS

DRAWING TITLE

PSU Charger Unit 3 Post

SCALE 1 : 20 @ A1
PROJECT NO Project Number
STATUS
DRAWING NO

A124
REVISION