



FLAGPOLE SIGNAGE  
FRONT ELEVATION  
1:50

- LETTERED PANELS ARE SQUARED MILLED AND WITH FOILED ACRYL GLASS DEPOSITED 1780 X 550 mm
- FRONT PANELS ARE ALUMINIUM LACQUERED. COLOUR: WHITE ALUMINIUM (RAL 9006)
- 200 MM DIA. POWDER COATED STEEL POLE WITH CAPPED PLATE WELDED TO THE TOP. POLE TO BE 5.98m HIGH ABOVE GROUND LEVEL. COLOUR: GRAPHITE GREY (RAL 7204)
- 4NO. TRIANGULAR GUSSETS WELDED TO THE 500 X 500 X 30mm BASE PLATE AND POLE. BASE PLATE TO HAVE 4 DRILLED HOLES FOR FIXING TO THE CONCRETE BASE.
- FOUNDATION STATICS CALCULATION BY STRUCTURAL ENGINEER.
- ROOT CAGE TO BE INSTALLED TO CONCRETE BASE 4000 X 1240 X 1000mm. TO STRUCTURAL ENGINEERS' DESIGN AND SPECIFICATION.
- DUCTWORK FOR CABLES BY CUSTOMER WITH AN UNDERGROUND CABLE ACCORDING TO DESCRIPTION 230V~/50 HZ

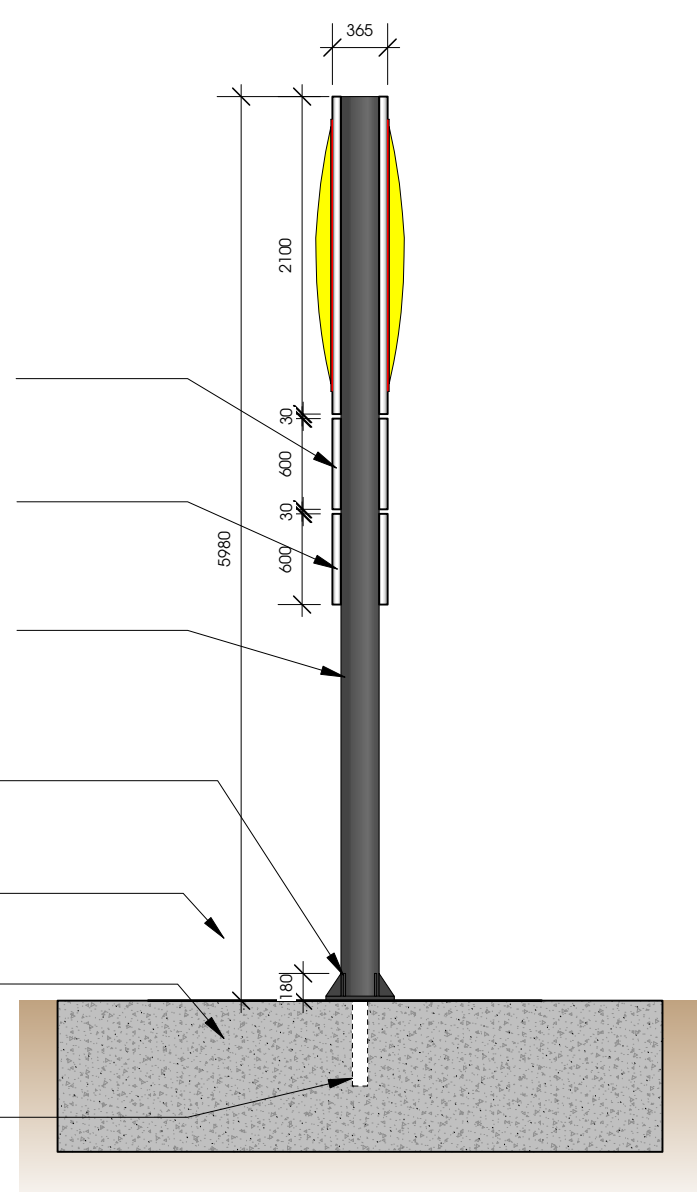


FLAGPOLE SIGNAGE  
SIDE ELEVATION  
1:50

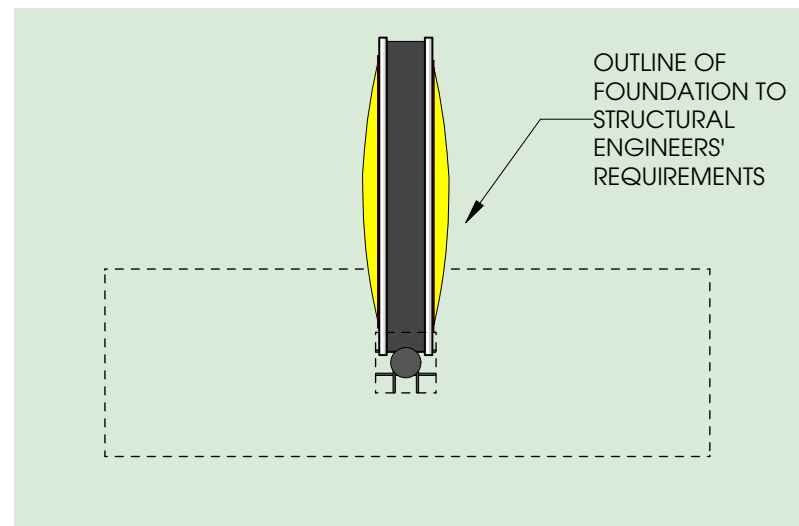

FLAGPOLE SIGNAGE  
PLAN VIEW  
1:50

<p><b>SPECIFICATION:</b></p> <p>ALUMINIUM PANELS LACQUERED IN WHITE ALUMINIUM (RAL 9006)</p> <p>BASE LACQUERED IN GRAPHITE GREY (RAL 7204)</p> <p>LIDL LOGO AS LIGHTING BOX WITH THERMOFORMED, CURVED AND EXTENSIVE PRINTED ACRYLIC LOGO SHELL</p> <p>LETTERED PANELS ARE MILLED WITH FOILED ACRYLIC GLASS DEPOSITED</p> <p>GALVANIZED STEEL FRAME CONSTRUCTION</p> <p>ANCHORING CAGE TO STRUCTURAL ENGINEER REQUIREMENT</p>	<p><b>ILLUMINATION WITH SAPS-LEDS:</b></p> <p>FUSE 16A, FI 30mA</p> <p>UNDERGROUND CABLE NYJ-J, WIRE CROSS SECTION FOR CABLE LENGTH MAX. 120 m<sup>3</sup> X 1,5mm<sup>2</sup></p> <p>WIRE CROSS SECTION FOR CABLE LENGTH MORE THAN 120 m<sup>3</sup> X 2,5mm<sup>2</sup></p> <p>POWER CONSUMPTION: 160 W, + 30 W PER ADDITIONAL MODULE (MAXIMUM OF TWO) POWER INPUT: 2,25A, COS PHI &gt; 0,93</p> <p>LUMINANCE YELLOW UNDIMMED: APPROX 440 cd/m<sup>2</sup></p> <p>LUMINANCE YELLOW DIMMED: FROM APPROX. 80 cd/m<sup>2</sup> TO 460 cd/m<sup>2</sup></p>
------------------------------------------------------------------------------------------------------------------------------------------------------------------------------------------------------------------------------------------------------------------------------------------------------------------------------------------------------------------------------------------------------------------------------	-------------------------------------------------------------------------------------------------------------------------------------------------------------------------------------------------------------------------------------------------------------------------------------------------------------------------------------------------------------------------------------------------------------------------------------------------------------------------------------------------------------------------------------------------------------------

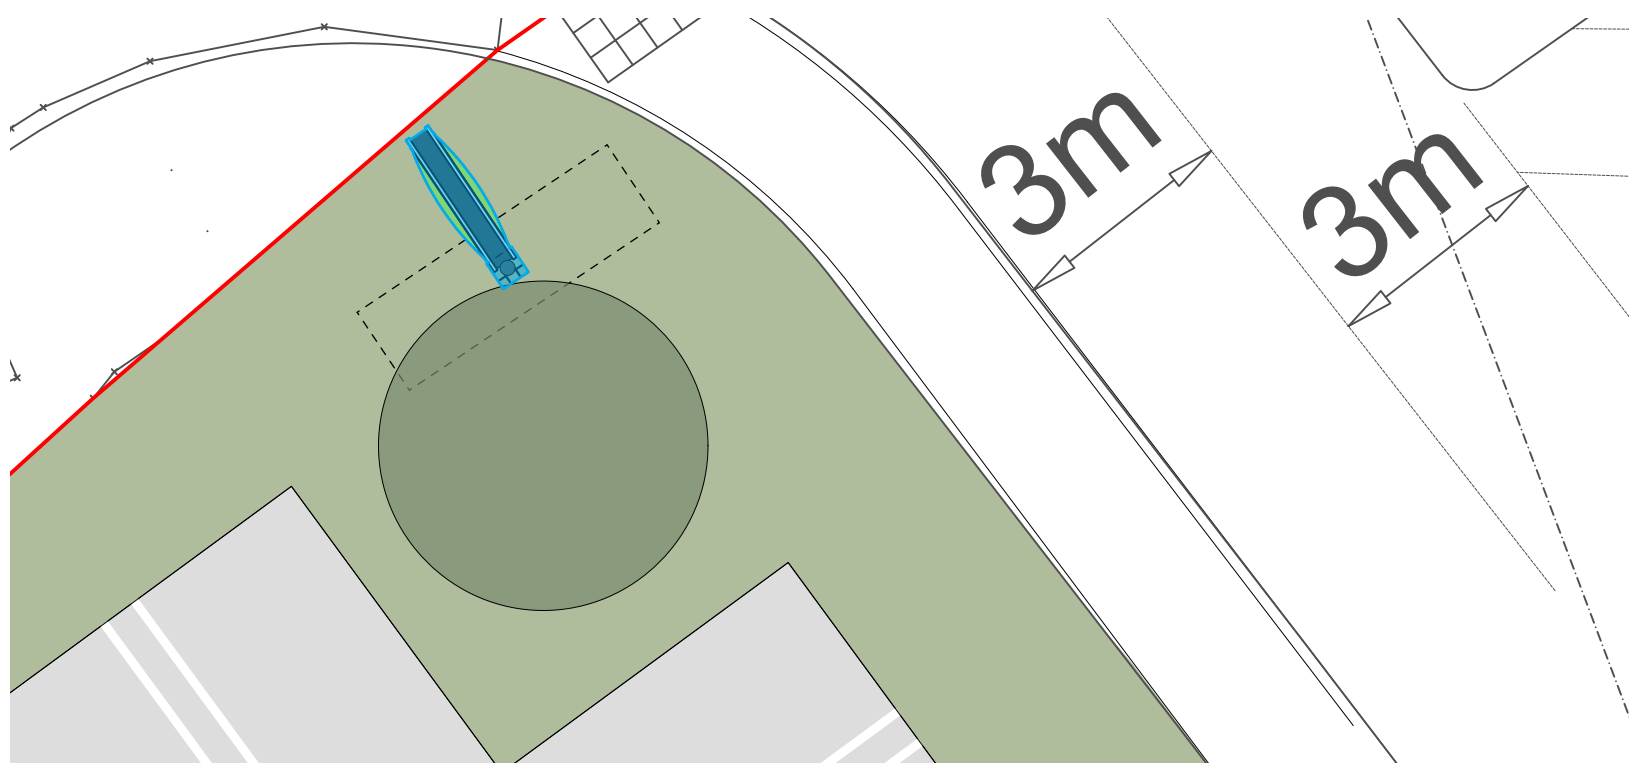

FLAGPOLE LOCATION  
1:100

Rev.	Date	Description	Drawn
------	------	-------------	-------

**htcarchitects**  
York Place Studio  
8 Britannia Street  
Leeds  
LS1 2DZ  
T:(0113) 244 3457  
W: www.htcarchitects.co.uk  
E: info@htcarchitects.co.uk

client  
**Lidl GB Ltd.**



project  
**Blackmoorfoot Road  
Huddersfield**

drawing title  
**Proposed Lidl Flagpole  
Details**

date **March 2025**  
status **Planning**  
scale **1:50 / 1:100 @ A3**  
drawn **DK** checked **BM**  
job no. **2783** dwg no. **P502** rev.