


Key

Notes

- Direction of light
- FL1 ⌘ Floor light
- SL1 ⌘ Spotlight
- WL1 ⌘ Wall light
- WL2 ⌘ Wall light

- Drawing to be cross-referenced with the Luminaire Schedule.
- Light fitting symbols are not to scale.
- Mounting and suspension heights are to the centre of the fitting.
- Dimensions are provided in millimeters.
- All external lighting within transition spaces is to be operated via PIR control and shall switch off 1-2 minutes after absence has been detected.

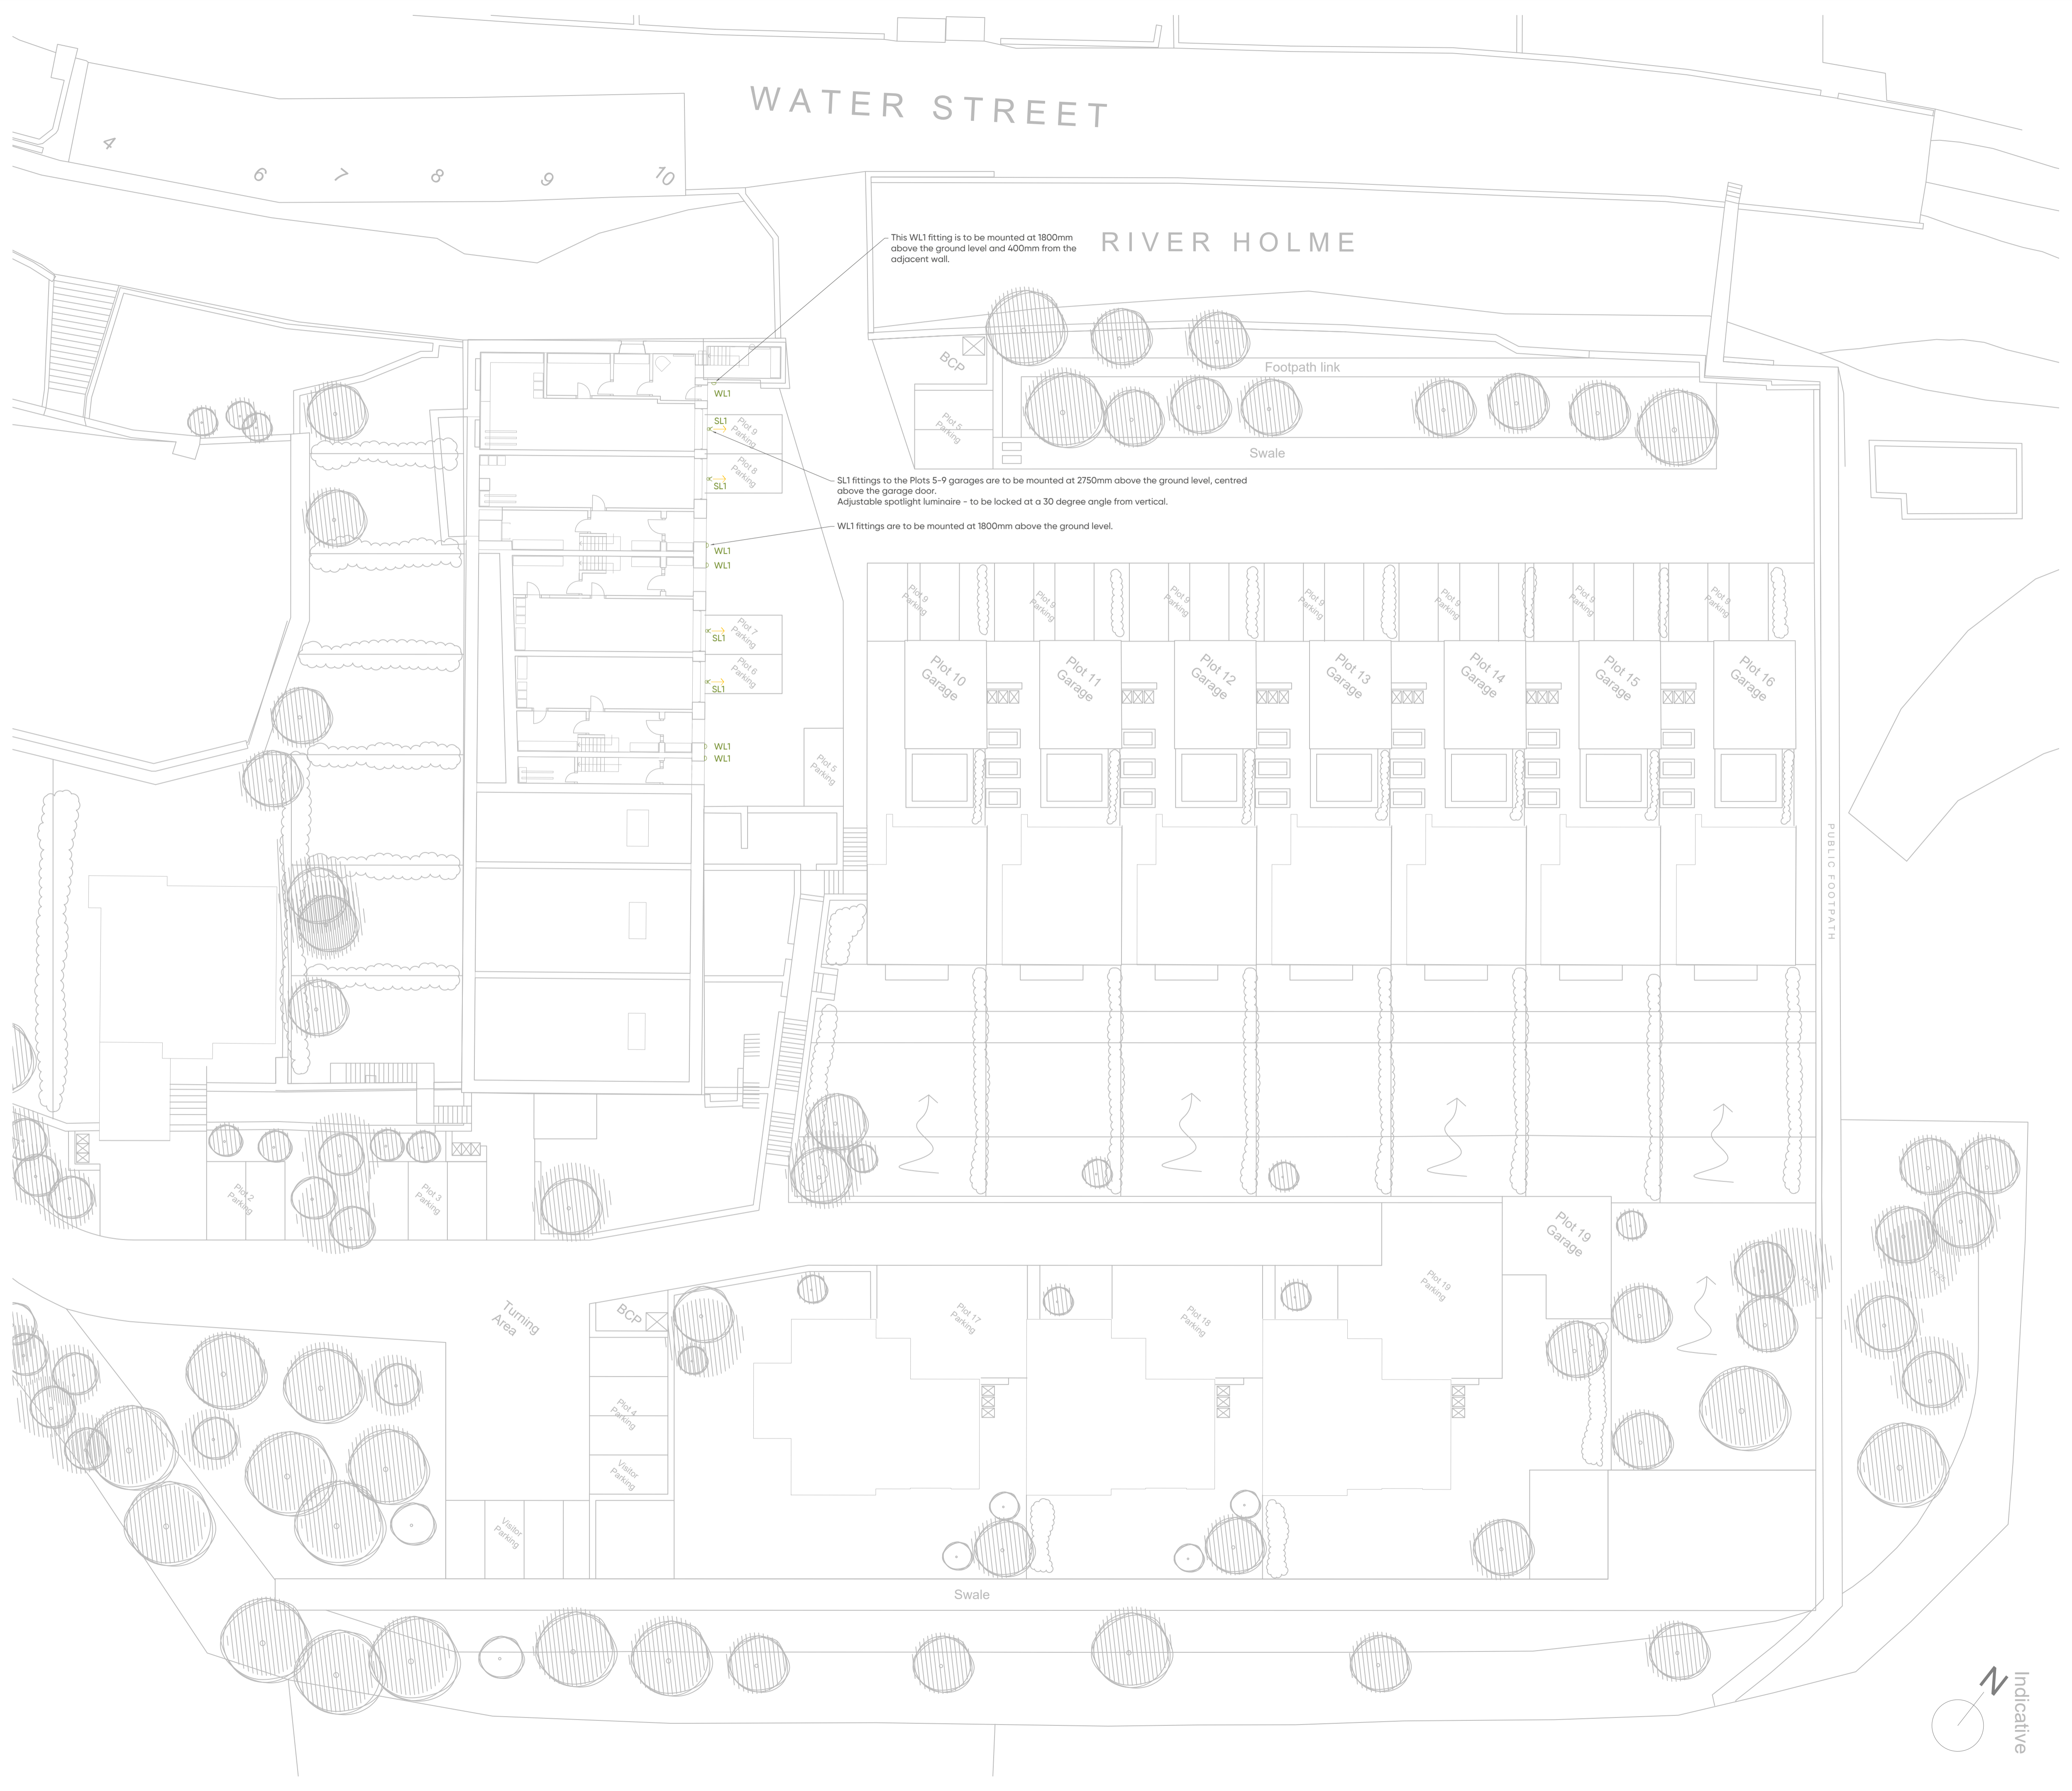

ECOLOGICAL LIGHTING SOLUTIONS
WILDLIFE-FRIENDLY LIGHTING DESIGN

Rev: 0
Reason: N/A
Status: For planning
Date: 04/12/25

Project: Hincliffe Mill

Client: Holroyd Homes

Drawing title: Layout Drawing - Lower Ground Floor

Drawing no.: P25168 - -01 - 01

Project no. P25168	Service no. S1	Iteration no. 10
Drawn by BR	Checked by JK	Scale 1:400 A3 1:200 A1

© This drawing is copyright of Ecological Lighting Solutions and must not be copied or reproduced in any form without permission

