


EXCW01 Outfall Base Plan and Section

Scale 1:20

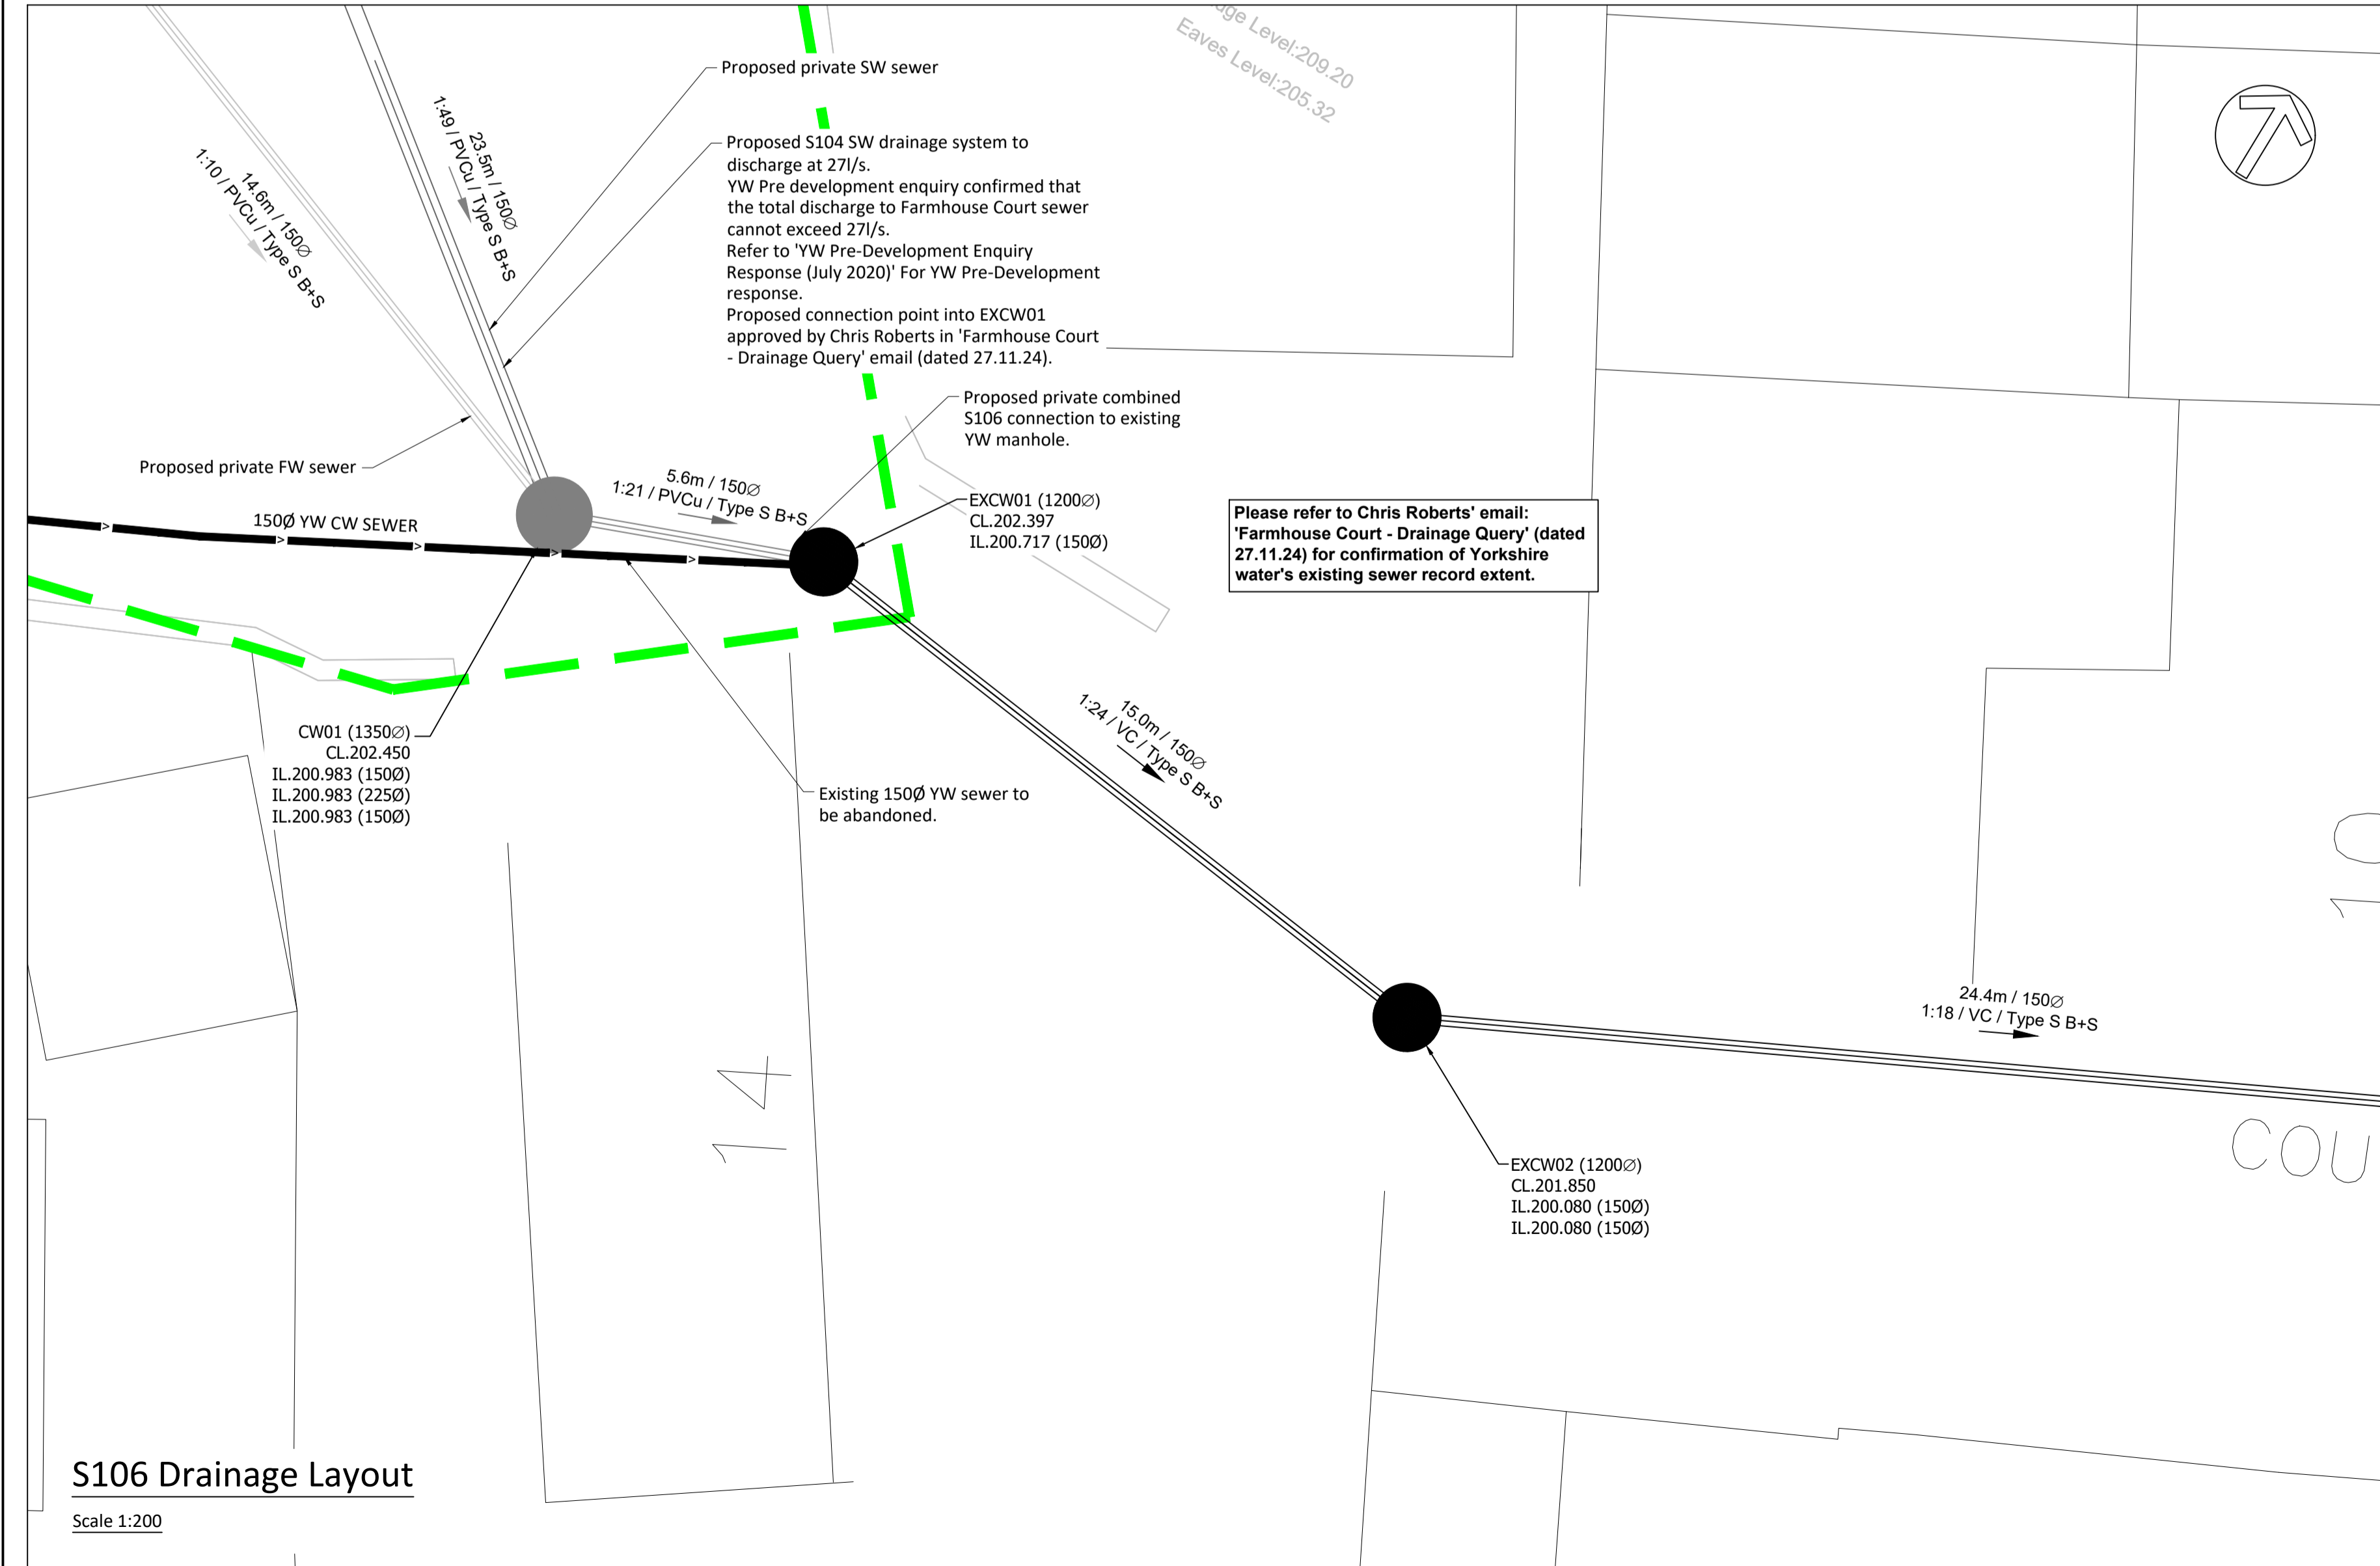

S106 Drainage Layout

Scale 1:200



Address = Farmhouse Court,
 Crosland Hill,
 Milnsbridge,
 Kirklees,
 West Yorkshire,
 England,
 HD4 5PH,
 United Kingdom

Easting = 411711
 Northing = 414884

Datum: OS Level Datum
 Using the OS GPS Network and applying
 OSGM15 National Geoid Model to obtain
 local area conditions.

Do Not Scale

Drawing Notes

Drawing & schedule based on the following information:
 Architect's drawing/model: REF#214_0880_Technical Planning Layout (Full Site)_For Information_D_0
 Revision: 0
 Received: 21.08.24
 Topographic Survey: 3606-SU001-005_25 Surveys Ltd - Sitewide Topo with Added Trees (October 2023)_For Information_B_0
 Revision: 8
 Received: 8

Health, Safety & Environmental Notes

Key:

- Existing YW Combined Sewer
- Proposed S104 Surface Water Sewer
- Proposed S104 Foul Water Sewer
- Proposed S104 Combined Sewer
- Site boundary

07.02.25	Drawing updated as per YW comments	AT	RP	P2
18.12.24	Initial Issue	ASe	AT	P1
Date	Description	By	Chk	Rev

ADEPT
 CIVIL AND STRUCTURAL CONSULTING ENGINEERS

Web: www.adeptcsce.com
 Email: info@adeptcsce.com
 Tel: 0113 239 4518

Office Address:
 1912 Mill, Sunny Bank Mills,
 Farsley, Leeds LS28 5UJ

Project: **Blackmoorfoot, Huddersfield**

Title: **S106 Farmhouse Court Layout**

Client: **Countryside Partnerships**

Scale @ A1	Initial author	Initial checker	Approver	Initial Date
1:100	ASe	AT	RP	NOV 24
Status	Purpose	Adept Project Number		
S2	Preliminary	08.24007		
Project-Originator-Functional Breakdown-Spatial Breakdown-Form-Disipline-Number				Rev:
08.24007-ACE-00-ZZ-D-C-1650				P2