



SECTION C - RIVERSIDE WALK

- Later Phase Development Works (submitted under a separate application at later date)

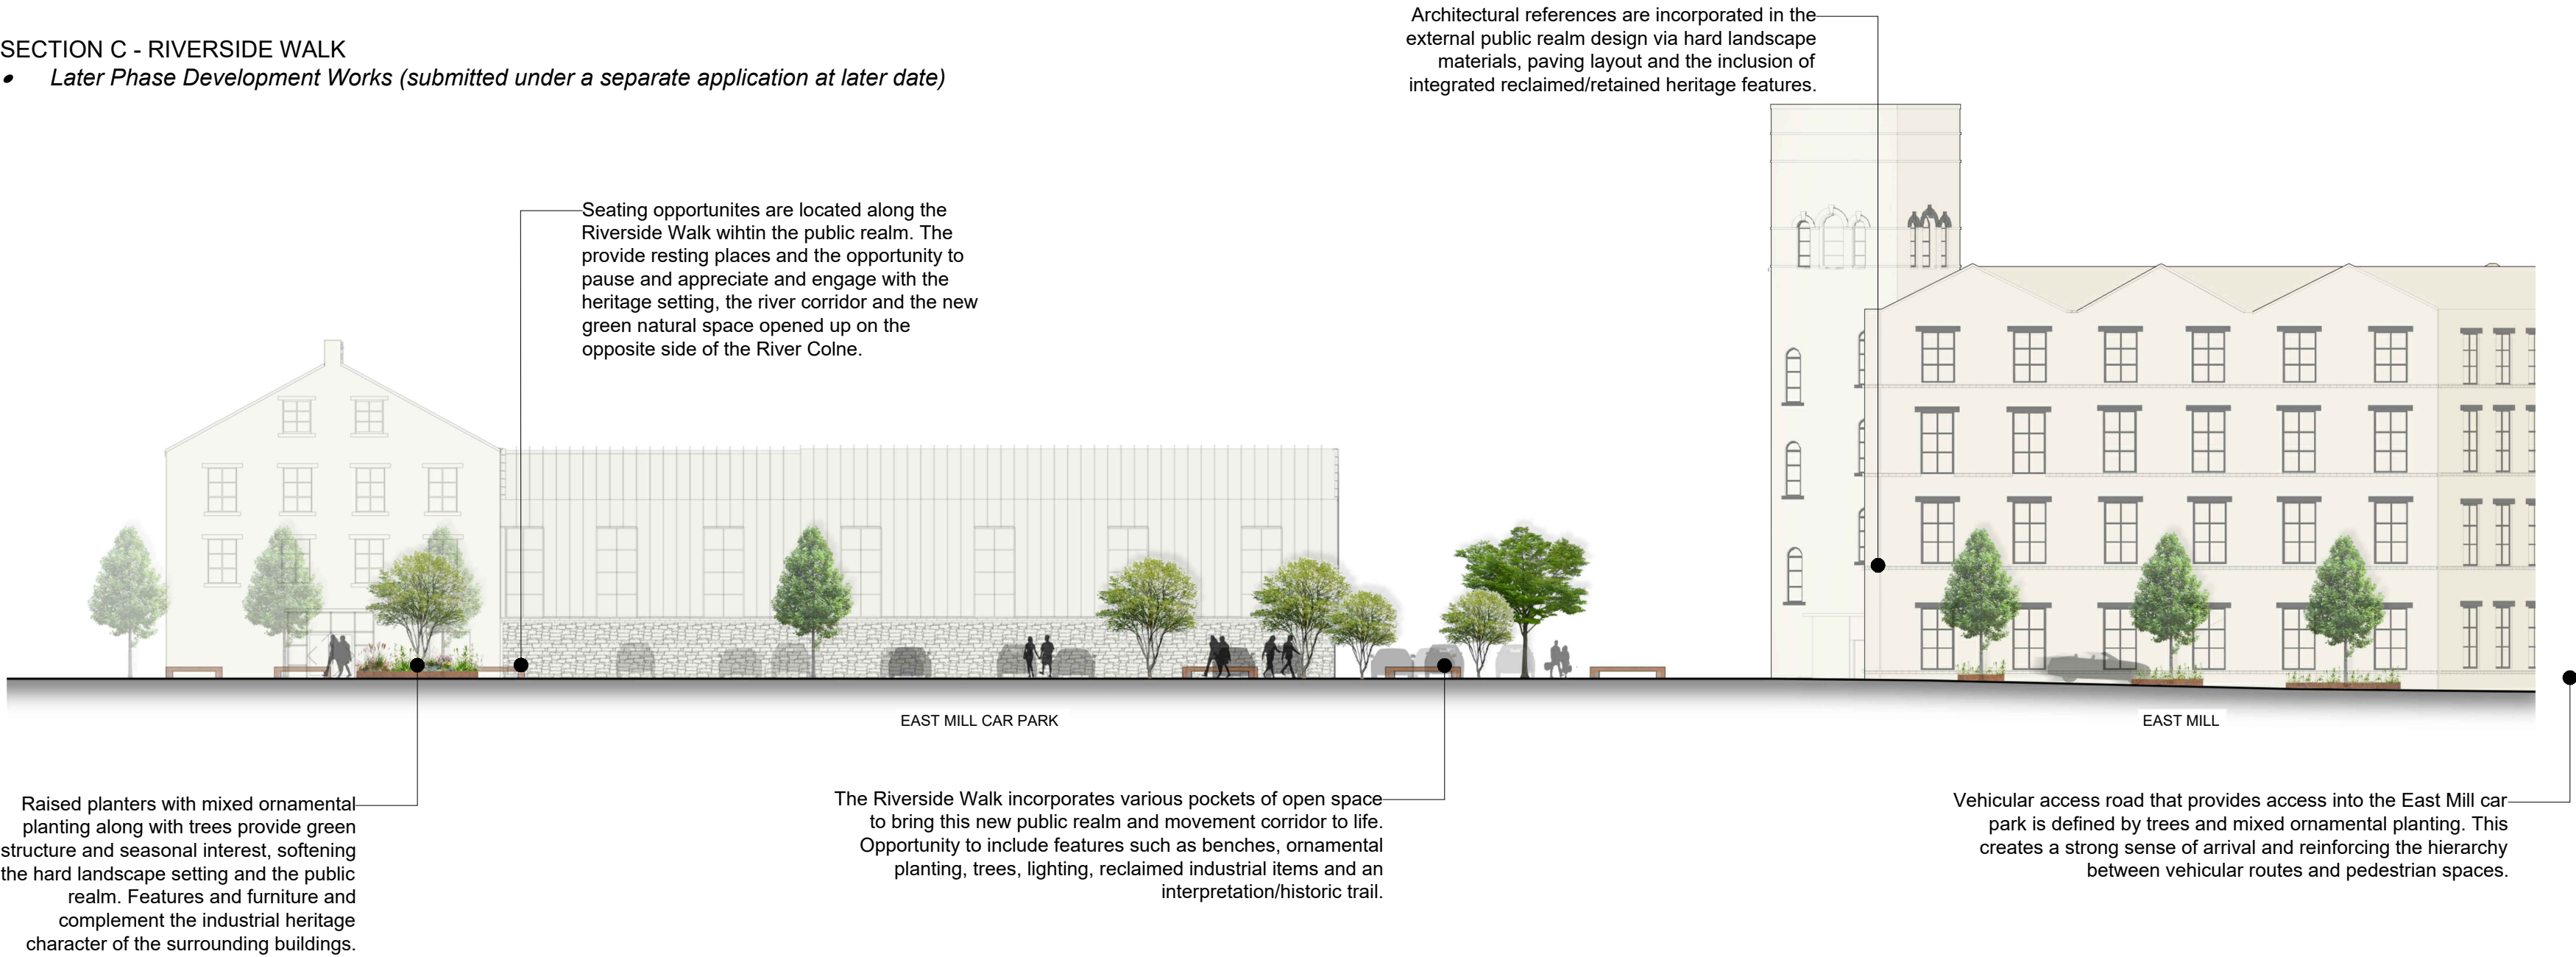


SECTION D - BROUGHAM STUDIOS, UNIT C & RIVERSIDE WALK

- Phase 1 Development Works of Full Application - Brougham Studios & Unit C
- Later Phase Development Works (submitted under a separate application at later date) - Riverside Walk

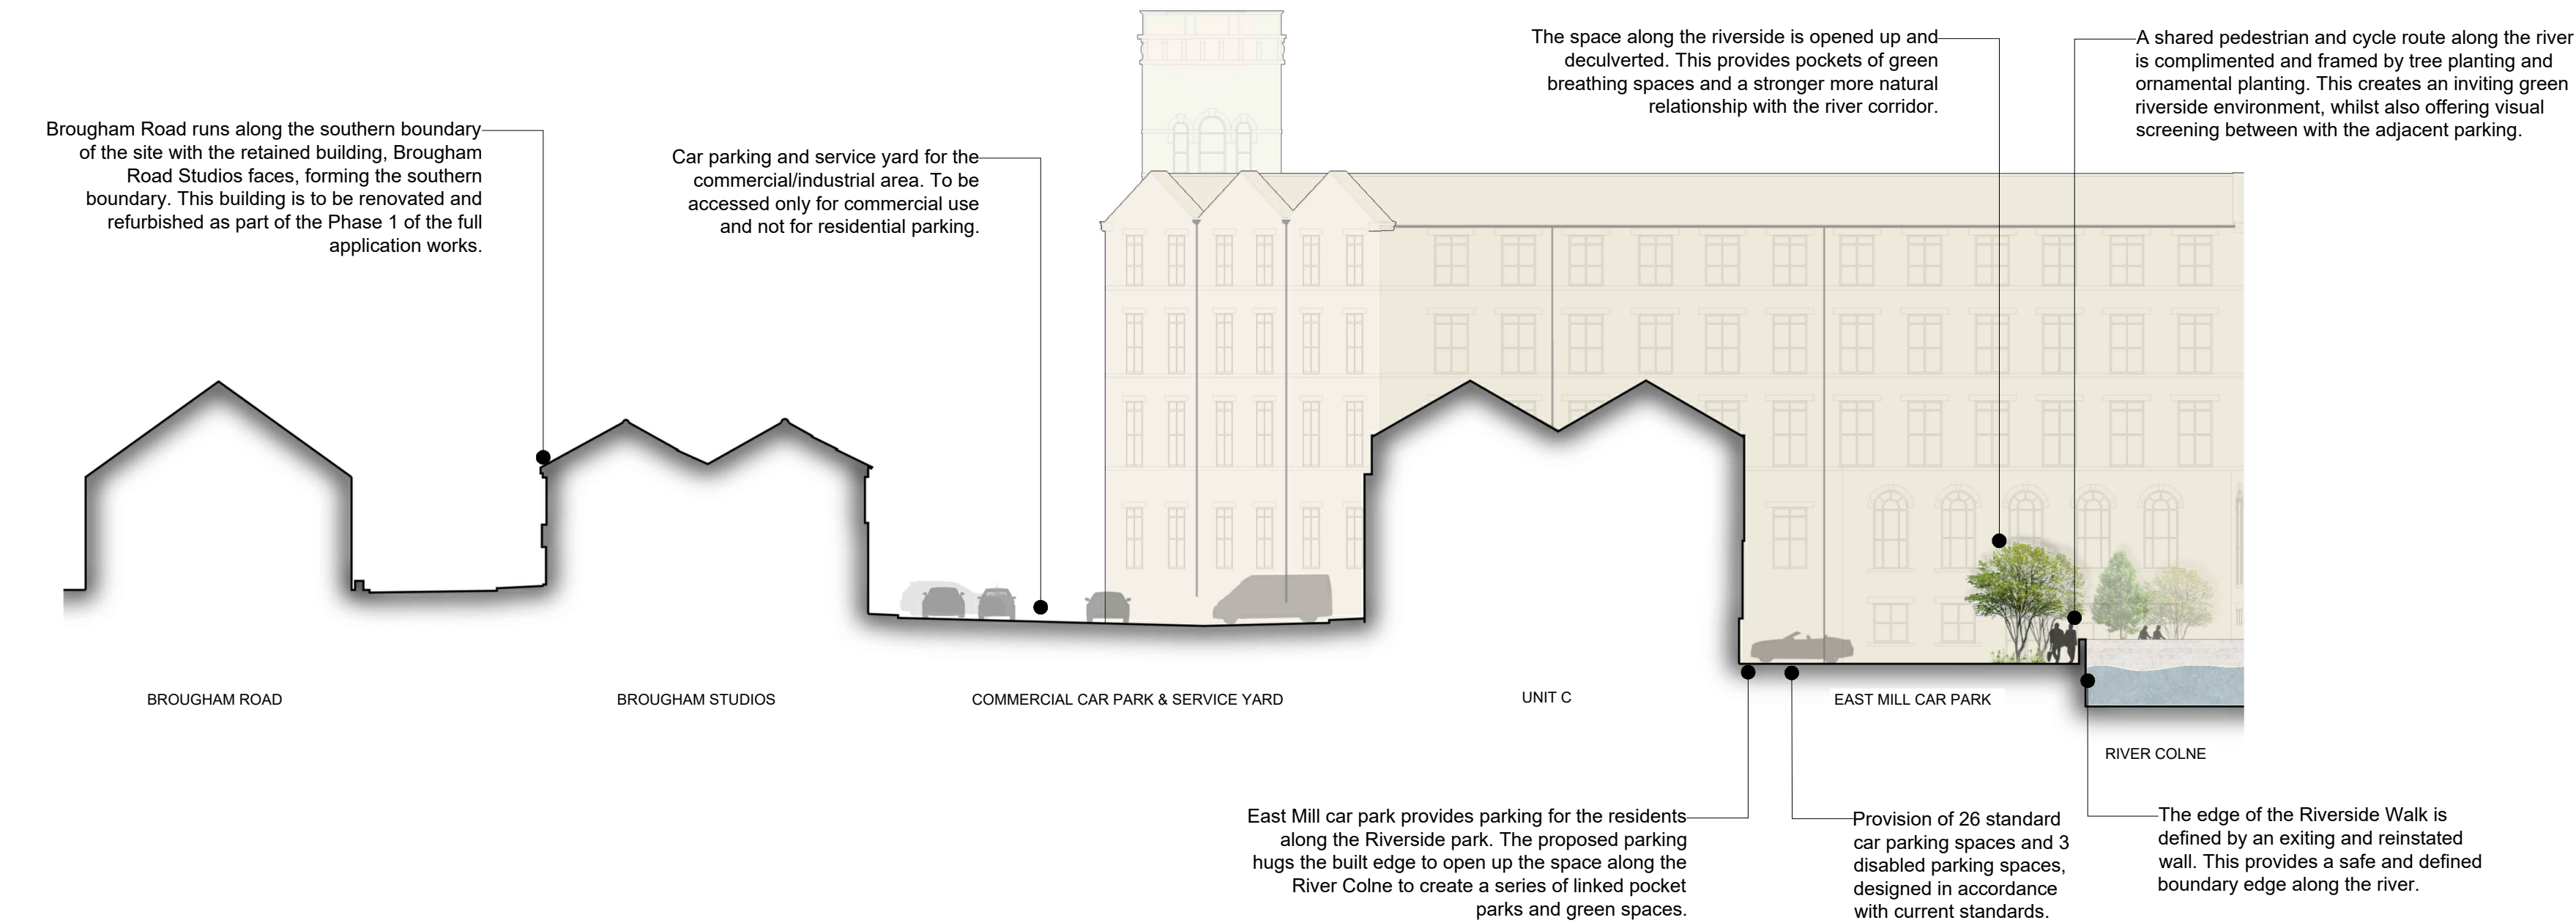

NOT FOR CONSTRUCTION

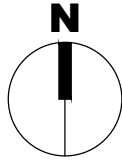

NOTES:

NOT FOR CONSTRUCTION, all dimensions to be confirmed on site. Based on layout drawing - KPP 2013 PROPOSED MASTERPLAN LINEWORK.

For additional information please refer to individual drawing notes and annotations along with the project drawing issue sheets. If in any doubt, please contact Landscape Architect for clarification.

The drawing is to be read in conjunction with the following drawings:
1. PWP-847-DR-0001-Illustrative Outline Landscape Masterplan
2. PWP-847-DR-0002-Sections_Sheet_1_of_2

Please note this list is not intended to be a comprehensive list of all details and their references, it is intended to be used for ease of navigation and information finding purposes only. For a full and up to date list of ALL current drawing information, please refer to the latest drawing register.

All foundation and build ups as per engineer's / supplier's specification.
Refer to engineer's drawings for site levels, drainage and lighting layout.

Contractor to be fully satisfied with locations of services prior to excavations.

02	FOR PLANNING - PLANNING REFERENCES	20/04/26	JMo	LW	SH
01	UPDATED	19/01/26	JMo	LW	SH
00	FOR PLANNING	19/12/25	JMi	LW	SH
REV	DESCRIPTION	DATE	ATHR	CHK	APP

PROJECT TITLE

New Mills Marsden

DRAWING TITLE

Illustrative Site Sections
Sheet 2 of 2

CLIENT

Crowther Bruce & Company Ltd



PWP Design Ltd
Unit 1, Whiteley Court
Pool Road
Otley
LS21 1FR
0113 4572508
info@pwpdesign.co.uk
© copyright reserved

AUTHOR	CHECKER	APPROVER	SCALE	REVISION
JMo	LW	SH	1:250	02
STATUS	FOR PLANNING	DRAWING NUMBER	PWP-847-DR-L-0003	