



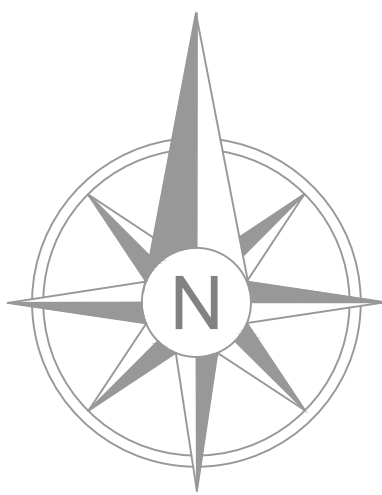

SITE PLAN  
SCALE - 1:250

NOTE:  
DRAINAGE PLAN TO BE READ IN CONJUNCTION WITH  
HAIGH HUDDLESTON DRAINAGE LAYOUT  
REF: 8060-004 MAIN ROAD & SEWER PLAN

ALL LEVELS ARE TAKEN FROM AND SHOULD BE READ  
IN CONJUNCTION WITH HAIGH HUDDLESTON EXTERNAL  
WORKS  
REF: 8060-021-01 EXTERNAL WORKS - PLAN 1

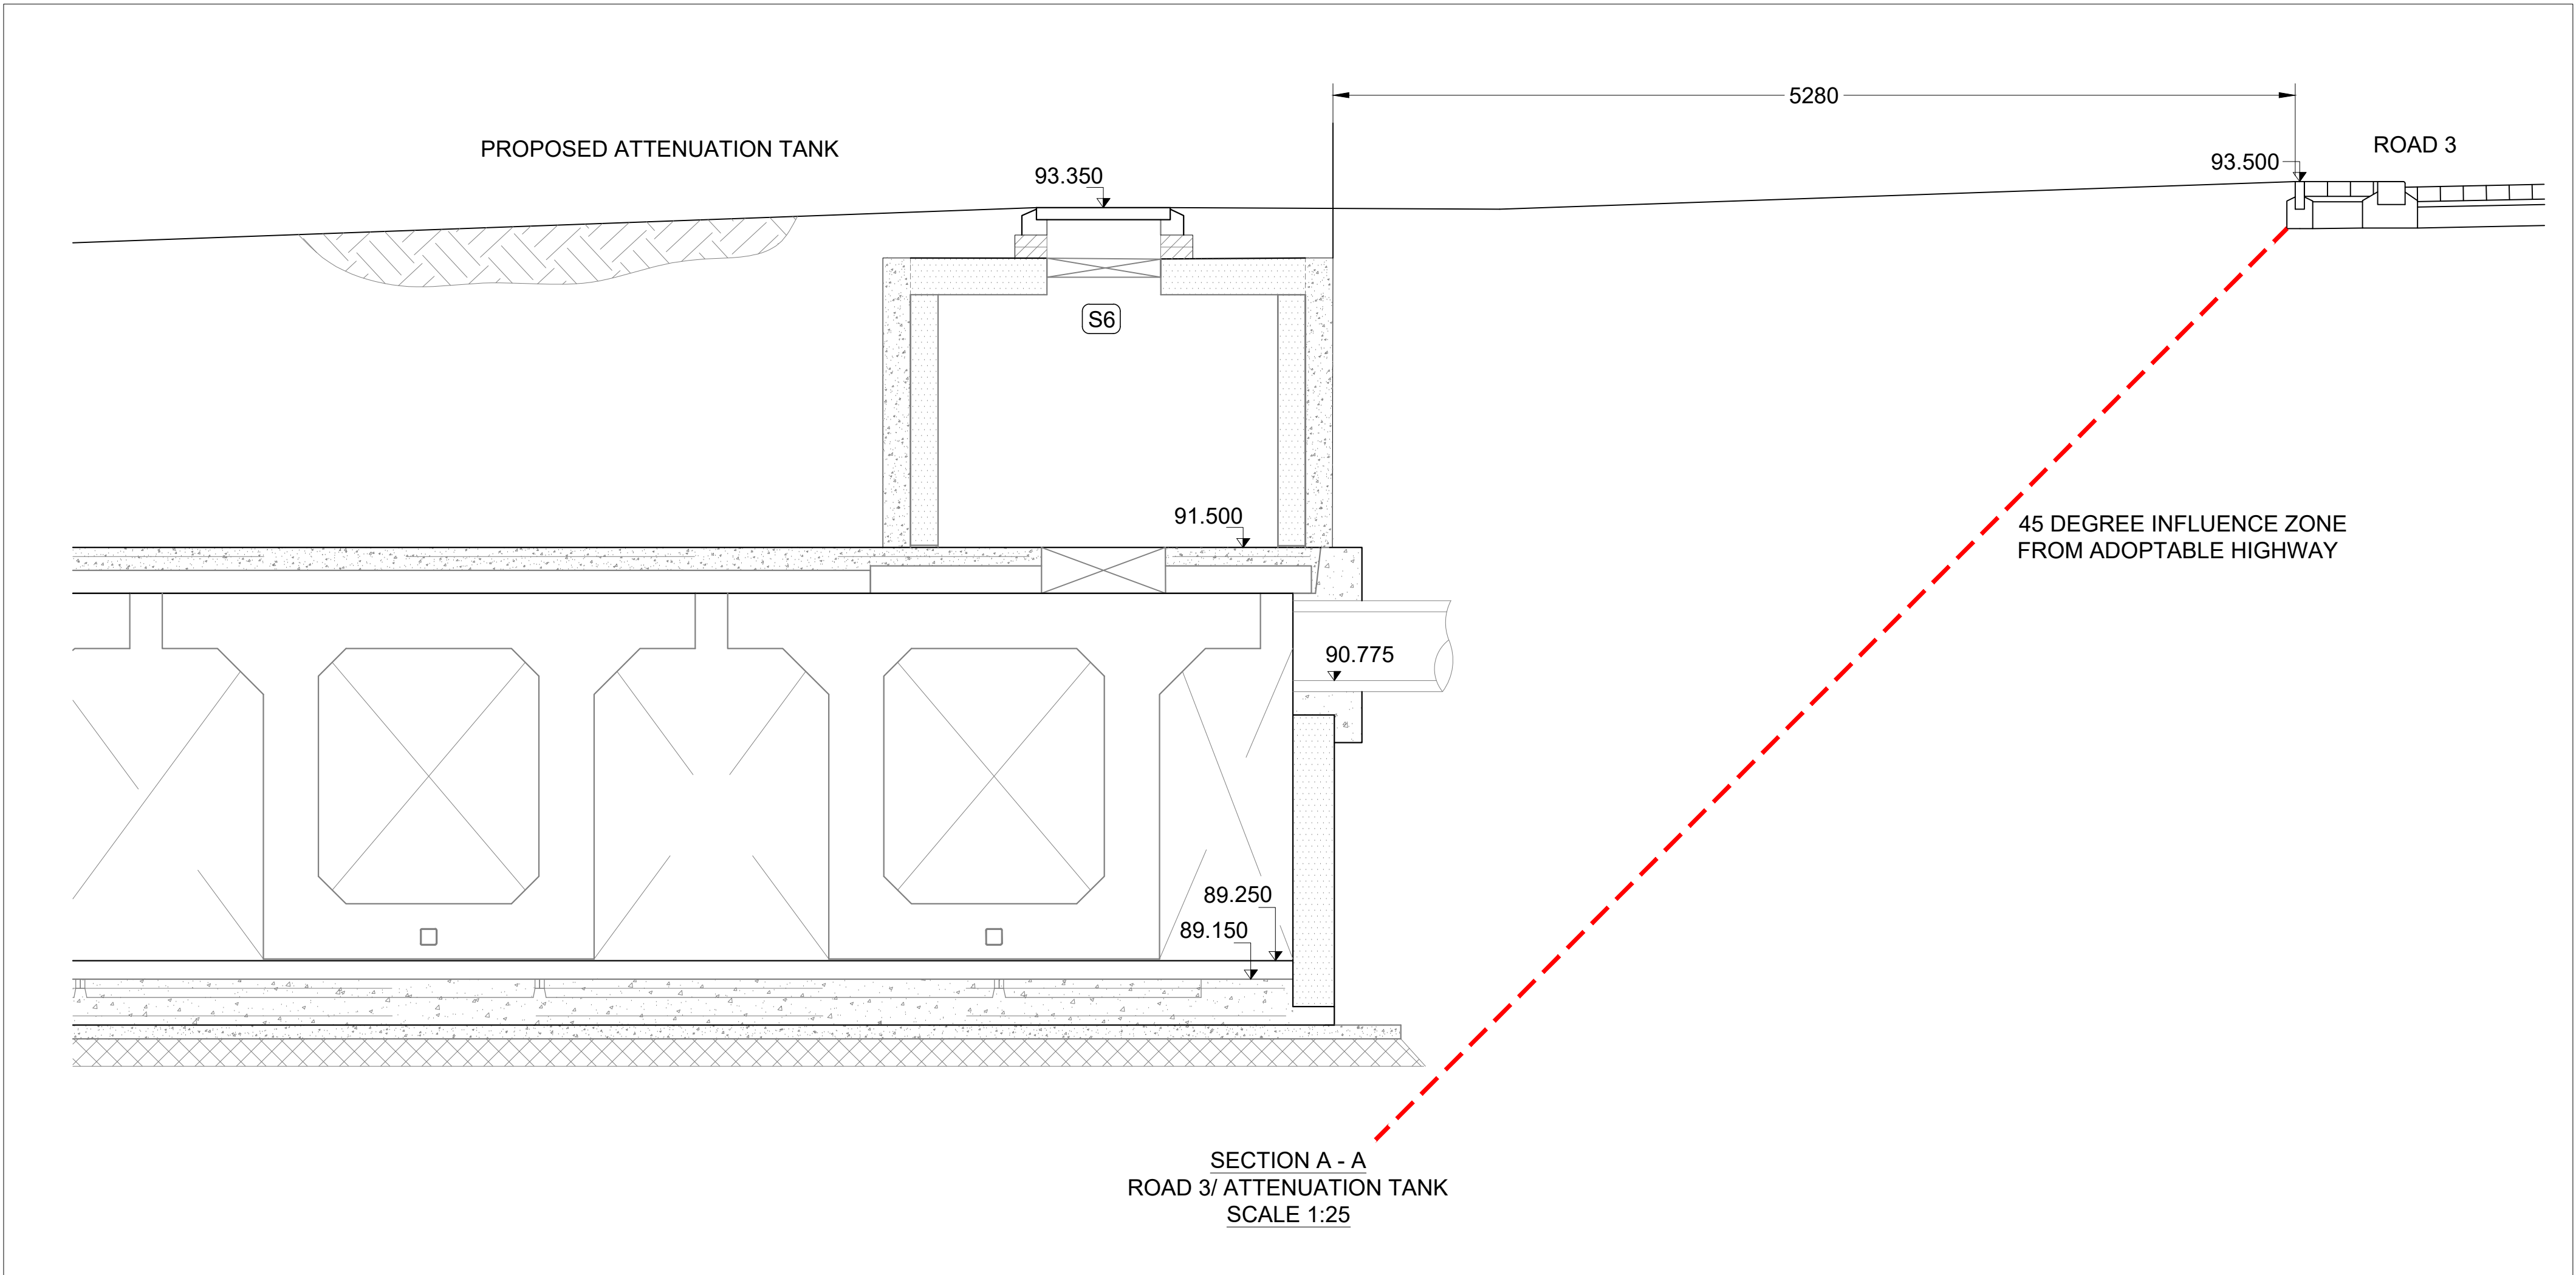

SECTION A - A  
ROAD 3/ ATTENUATION TANK  
SCALE 1:25

Notes:

1. THE COPYRIGHT OF THIS DRAWING IS VESTED IN Homes by honey
2. WORK TO FIGURED DIMENSIONS ONLY.
3. THIS DRAWING IS TO BE READ IN CONJUNCTION WITH ALL RELEVANT ARCHITECTS, SERVICE ENGINEER'S AND Homes by honey DRAWINGS AND SPECIFICATIONS.

|         |              |     |       |
|---------|--------------|-----|-------|
| REV:    | DESCRIPTION: | BY: | DATE: |
| STATUS: |              |     |       |

homes by honey  
Third Floor, 197 Wards Exchange  
Ecclesall Road, Sheffield  
S11 8HW  
[www.homesbyhoney.co.uk](http://www.homesbyhoney.co.uk)



|                                                      |                     |                |                |
|------------------------------------------------------|---------------------|----------------|----------------|
| SITE: FENAY BRIDGE                                   |                     |                |                |
| TITLE: CONDITION 25 & 26<br>ROAD 3/ ATTENUATION TANK |                     |                |                |
| SCALE AT A1:<br>1:250/ 1:25                          | DATE:<br>12/08/2025 | DRAWN:<br>JB   | CHECKED:<br>JB |
| PROJECT NO:<br>C005                                  | DRAWING NO:<br>5010 | REVISION:<br>- |                |