


GROUND FLOOR PLAN



FIRST FLOOR PLAN

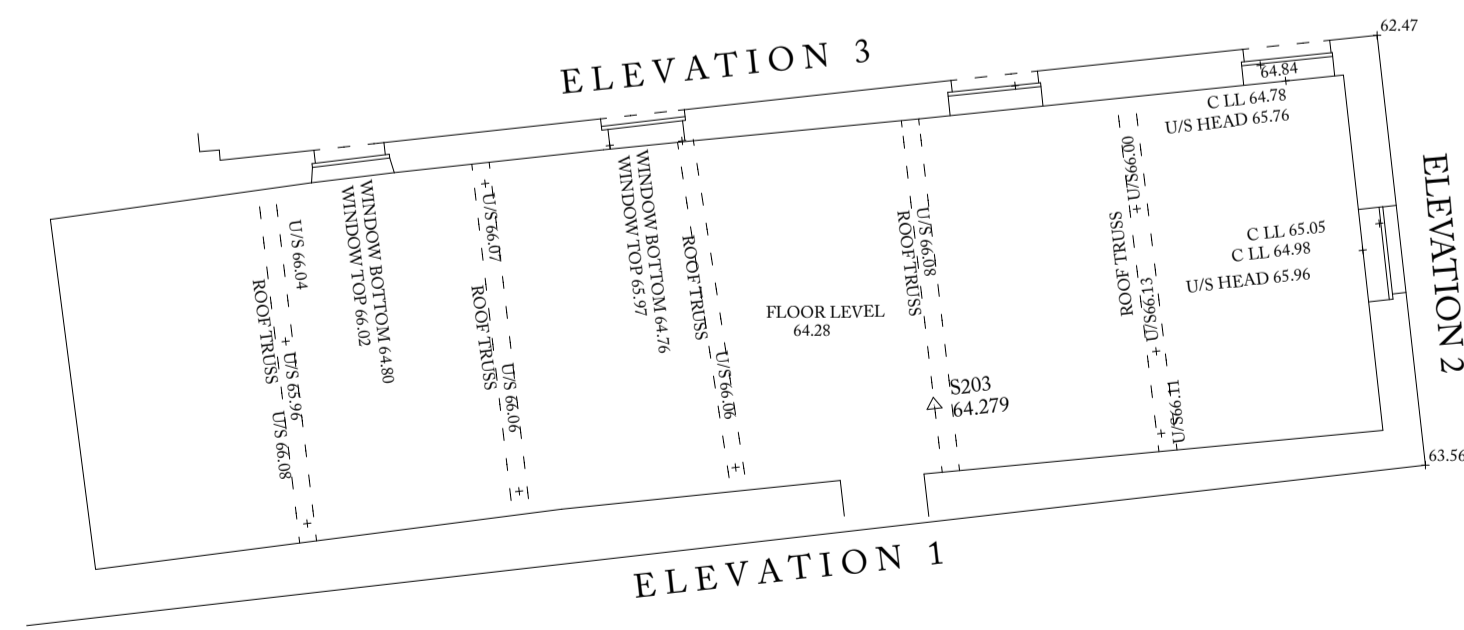

ANCHOR HOUSE, DEWSBURY MILLS
THORNHILL ROAD, DEWSBURY, WF12 9QE
TEL. (01924) 467621 FAX (01924) 459970
E-MAIL: ELS@ELBANE.COM

LOCATION
**FLOOR PLANS
OF BARN, CALEDONIAN ROAD**

CLIENT
ROBINSONS GROUP

LEGEND

AV	AIR VALVE	CC	CONCRETE COVER	FWS	FOLI WATER SEWER	LP	LAMP POST	ST	STOP TAP
BH	BORHOLE	CM	CABLE MARKER	GV	GAS VALVE	MC	METAL COVER	SV	STOP VALVE
BS	BUS STOP	CP	CATCH PIT	HV	HIGH VOLTAGE	MV	MEDIUM VOLTAGE	SWS	SURFACE WATER SEWER
BT	BRITISH TELECOM	CTV	CABLE TV LC	IC	INSPECTION COVER	P	POST / POLE	TL	TRAFFIC LIGHTS
		DP	DOWN PIPE	IB	JUNCTION BOX	RE	RODDING EYE	TP	TELEGRAPH POLE
		ECP	ELEC. CABLE PIT	KW	KERB WEIR	RS	ROAD SIGN	TH	THRESHOLD
		EP	ELEC. POLE/PYLON	LB	LITTER BIN	VP	VENT PIPE	WM	WATER METER
		ER	EARTH ROD	LH	LAMP HOLE	W	WASH OUT	WO	WASH OUT
		FI	FIRE HYDRANT			SC	STOP COCK		

CC	CONCRETE COVER	FWS	FOLI WATER SEWER	LP	LAMP POST	ST	STOP TAP
CM	CABLE MARKER	GV	GAS VALVE	MC	METAL COVER	SV	STOP VALVE
CP	CATCH PIT	HV	HIGH VOLTAGE	MV	MEDIUM VOLTAGE	SWS	SURFACE WATER SEWER
CTV	CABLE TV LC	IC	INSPECTION COVER	P	POST / POLE	TL	TRAFFIC LIGHTS
DP	DOWN PIPE	IB	JUNCTION BOX	RE	RODDING EYE	TP	TELEGRAPH POLE
ECP	ELEC. CABLE PIT	KW	KERB WEIR	RS	ROAD SIGN	TH	THRESHOLD
EP	ELEC. POLE/PYLON	LB	LITTER BIN	VP	VENT PIPE	WM	WATER METER
ER	EARTH ROD	LH	LAMP HOLE	W	WASH OUT	WO	WASH OUT
FI	FIRE HYDRANT			SC	STOP COCK		

SURVEY NOT TO BE MOVED OR ROTATED
ALL SERVICES TO BE FIELD VERIFIED
Drawings remain the property of Ellam Land Surveys until all payments have been received
Copyright Ellam Land Surveys 2007.

SHEET 3 OF 3
SCALE 1 : 100
DRAWN N SYKES
CHECKED NS
DATE APRIL 07

LEVEL DATUM NEWLYN
GRID DATUM ARBITRARY
B.M. USED OBM on Corner of Cricket Ground
Value 47.58m

DRAWING NO. 5731/3

