


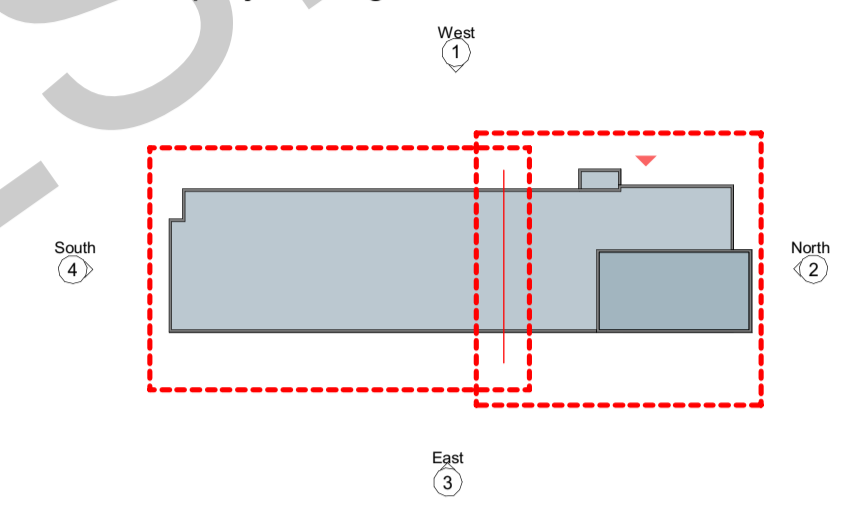

SCALE 1:100 @ A1

NOTE : PV layout subject to further coordination at next project stage




2 / 1207

Natural ventilation turrets with actuated dampers Bio-Solar Roofing system throughout the main roof Rooflights with guarding

03 - Roof_GA Plan - Planning - 1 of 2

Scale - 1 : 100

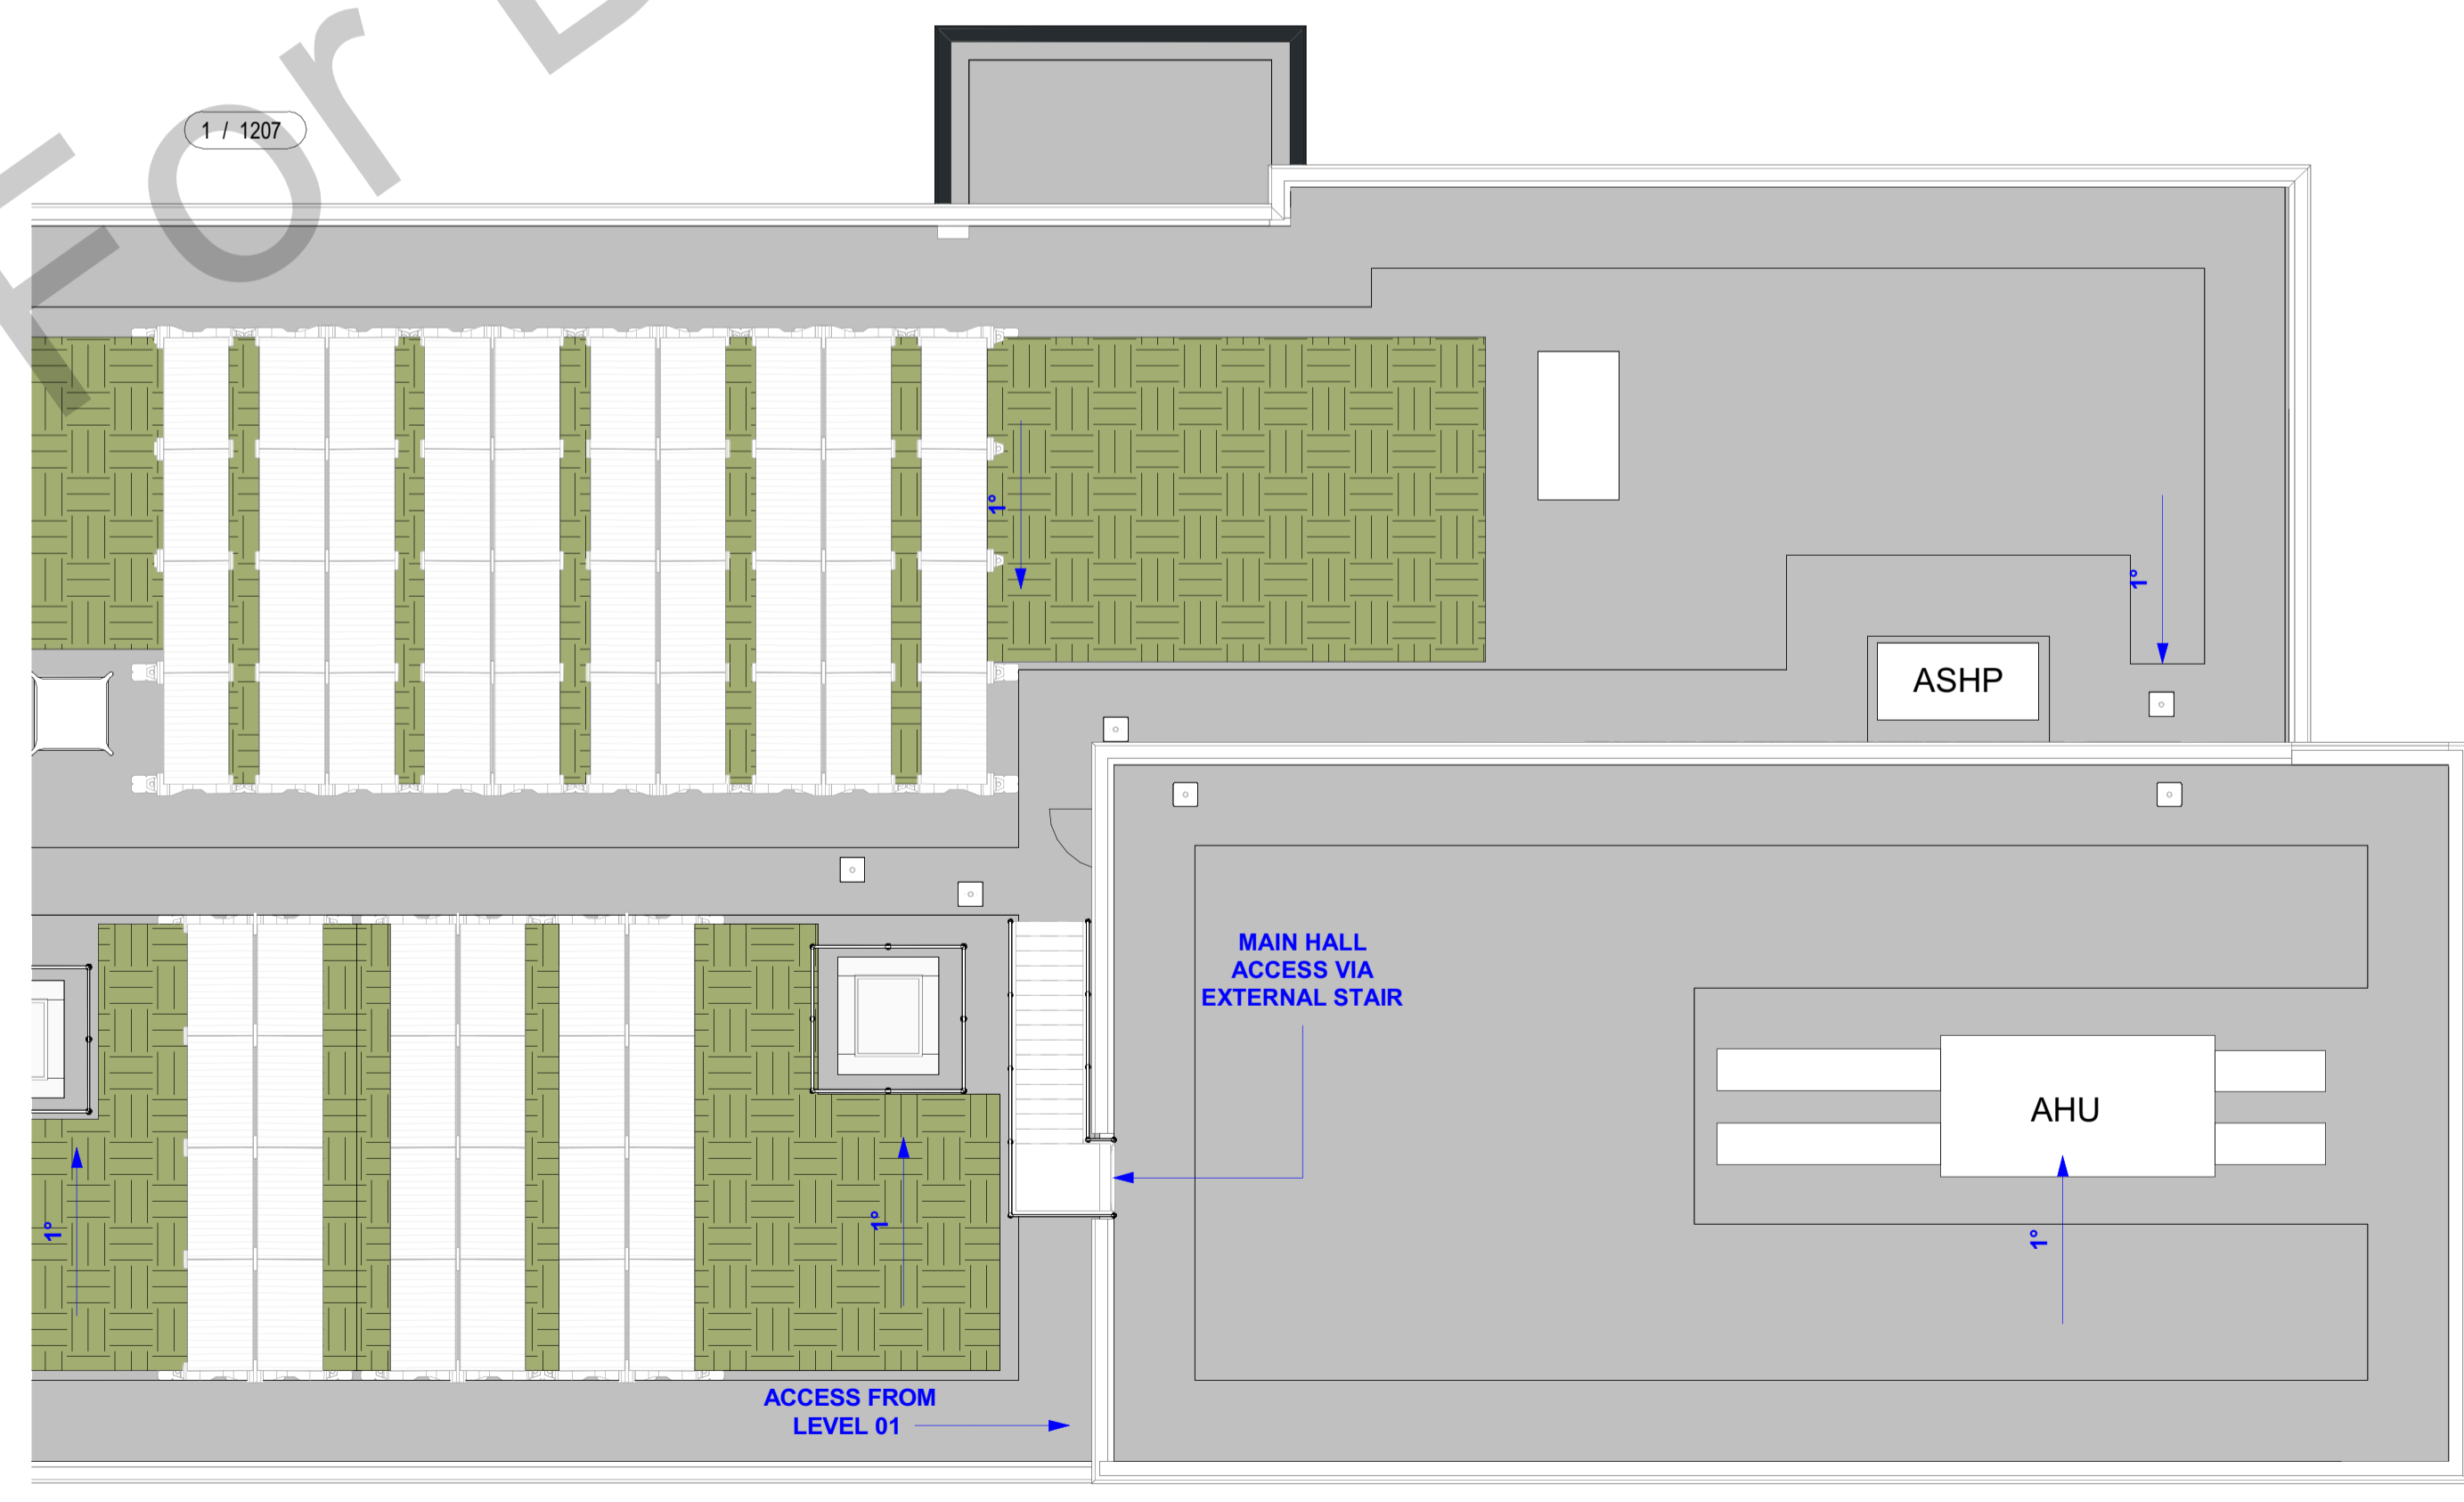

1 / 1207

03 - Roof_GA Plan - Planning - 2 of 2

Scale - 1 : 100

REV	DATE	DESCRIPTION
C01	09.02.26	End of Stage 3 Issue
P02	20.01.26	Touchpoint D Amendments
P01	29.10.25	Draft CP Submission

CLIENT

 Department for Education

CONTRACTOR

 BOWMER KIRKLAND

CONSULTANT

 PICK EVERARD

PROJECT
 Gomersal St Mary's Primary School

DRAWING TITLE
 Planning GA Level RF

DRAWING PURPOSE

DRAWN BY	DATE	CHK'D BY	SCALE	MEDIA
JHD	09.02.26	ALJ	As indicated	A1
CONTRACT DRAWING REFERENCE		STAGE:		
PM_40_40_34		1	2	3
		4	5	6
UNICLASS CODE		DEIR NAME		
PM_40_40_34		General Arrangement Roof Plans		
PROJECT - ORIGINATOR - ZONE - LEVEL - TYPE - ROLE - NUMBER				REVISION
SRP1134-PEV-01-RF-D-A-1207				C01

A3 - Authorised For DEVELOPED DESIGN