


CCTV LEGEND		
SYMBOL	DESCRIPTION	MANUFACTURER REF
	EXTERNAL CAMERA	HRYSON
	CCTV MONITOR	HRYSON

THIS DRAWING IS PROTECTED UNDER COPYRIGHT AND AT NO TIME MUST ANY PORTION OF THIS DRAWING BE REPRODUCED OR COPIED IN ANYWAY WITHOUT THE WRITTEN CONSENT OF THORNLEY & LUMB PARTNERSHIP LIMITED.

ALL DIMENSIONS ARE IN MILLIMETRES UNLESS STATED OTHERWISE AND MUST BE CHECKED ON SITE AND NOT SCALED FROM THIS DRAWING. THIS DRAWING IS TO BE READ IN ACCORDANCE WITH ALL RELEVANT SPECIFICATIONS AND ROOM DATA DOCUMENTS.

NOTES

- THE GENERAL ELECTRICAL INSTALLATION WORK SPECIFICALLY HAS BEEN INSTALLED AND CONFORMS TO COMPLY WITH THE FOLLOWING CURRENT STANDARDS, REGULATIONS AND ALL RECOMMENDATIONS COVERED UNDER BRITISH STANDARDS, UNLESS OTHERWISE DETAILED ELSEWHERE IN THIS SPECIFICATION:
- THE REGULATIONS FOR ELECTRICAL INSTALLATIONS, LATEST EDITION, AS ISSUED BY THE INSTITUTION OF ENGINEERING AND TECHNOLOGY, HEREINAFTER REFERRED TO AS THE IET 18TH EDITION WIRING REGULATIONS BS7671
 - THE REGULATIONS OF UK AND RELATED GOVERNING BODIES
 - THE ELECTRICITY SAFETY QUALITY & CONSULTANCY REGULATIONS 2002
 - THE ELECTRICITY SUPPLY AUTHORITY GENERAL AND LOCAL REQUIREMENTS
 - ALL RELEVANT BRITISH STANDARDS SPECIFICATIONS AND CODES OF PRACTICE
 - LOCAL FIRE OFFICERS REQUIREMENTS
 - THE FIRE PRECAUTIONS (WORKPLACE) REGULATIONS 1992
 - THE ELECTRICITY SUPPLY AUTHORITY GENERAL AND LOCAL REQUIREMENTS
 - DISABILITY & DISCRIMINATION ACT (DDA)
 - BS5839-1:2002 EMERGENCY LIGHTING
 - PART 18 - EXISTING NON-DWELLING 2005
 - ALL SUBSEQUENT AMENDMENTS TO THE ABOVE.

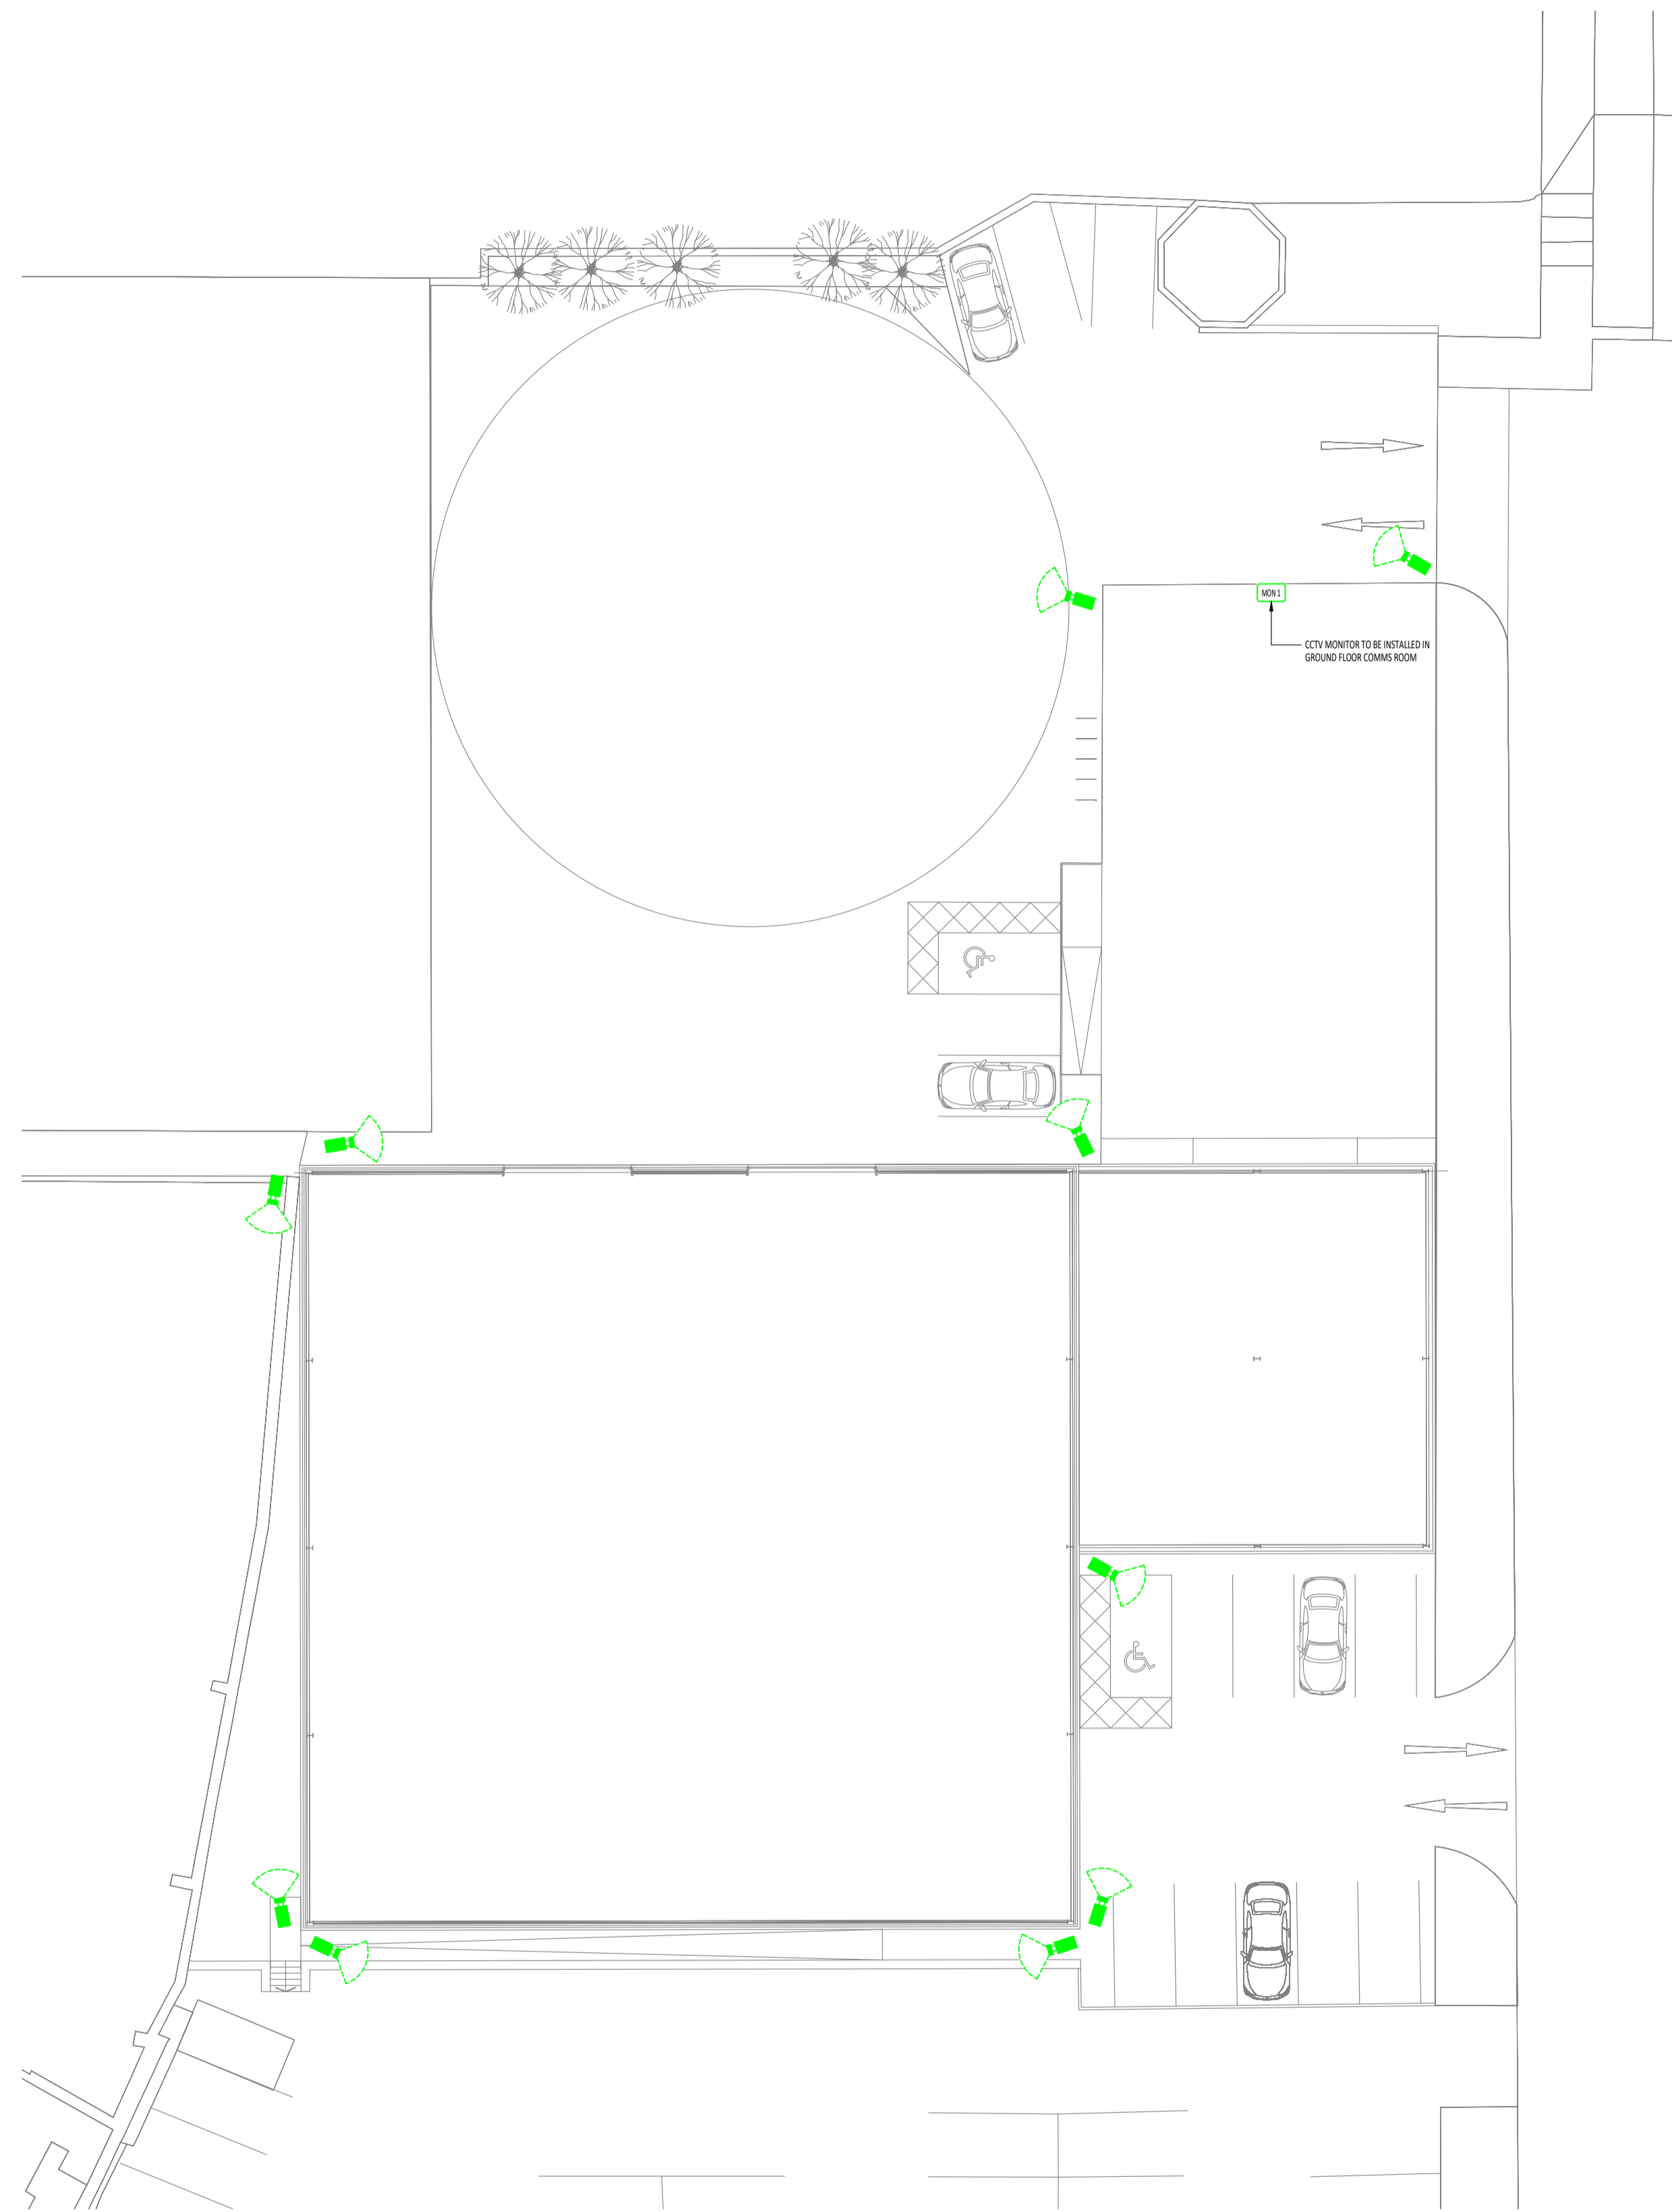

THIS DRAWING IS PRODUCED IN ACCORDANCE WITH ARCHITECTS/MAIN CONTRACTORS DRAWING REFERENCE

3310 05A Proposed Site Layout Plan

REV	DESCRIPTION	DRN	CHK	DATE
P1	PLANNING ISSUE	PDB	AS	25.03.26

PLANNING

Client
John L Brierley
Quay Street,
Huddersfield,
HD1 6QT



Architect
TD Jagger
3 Richmond House,
Caldene Business Park,
Mytholmroyd,
Hebden Bridge,
West Yorkshire, HX7 5JQ



Thornley & Lumb
Building Services Consultants

Head Office:
Century House, 257 Cutler Halghts Lane
Bradford, West Yorkshire, BD4 9JG
Telephone: +44(0)12 7468 7755

Southern Office:
2nd Floor, 216 Tower Bridge Road
London, SE1 2UP
Telephone: +44(0)12 7468 7755
www.thornleylumb.co.uk info@thornleylumb.co.uk

TLP Project No. C9263 Project Name: Turnbridge Mills Quay Street, Huddersfield

Drawing Title: External CCTV Layout

Engineer	Checked by	Drawn By
PDB	JF	KAB

Date: 09.12.25 Scale: 1:200 Size: A1

Project	Originator	Volume	Level	Type	Role	Number	Revision
C9263	-TLP	-XX	-XX	-DR	-E-	903	P1