


Notes

1. Do not scale this drawing. All dimensions must be checked/ verified on site. If in doubt ask.
2. This drawing is to be read in conjunction with all relevant architects, engineers and specialists drawings and specifications.
3. All dimensions in metres unless noted otherwise. All levels in metres unless noted otherwise.
4. Any discrepancies noted on site are to be reported to the engineer immediately.
5. This drawing should be printed and read in colour.

Design Notes

Legend

- PROPOSED SURFACE WATER
- ▨ PROPOSED ATTENUATION TANK
- PROPOSED LINEAR DRAINAGE
- FUTURE PHASE SURFACE WATER

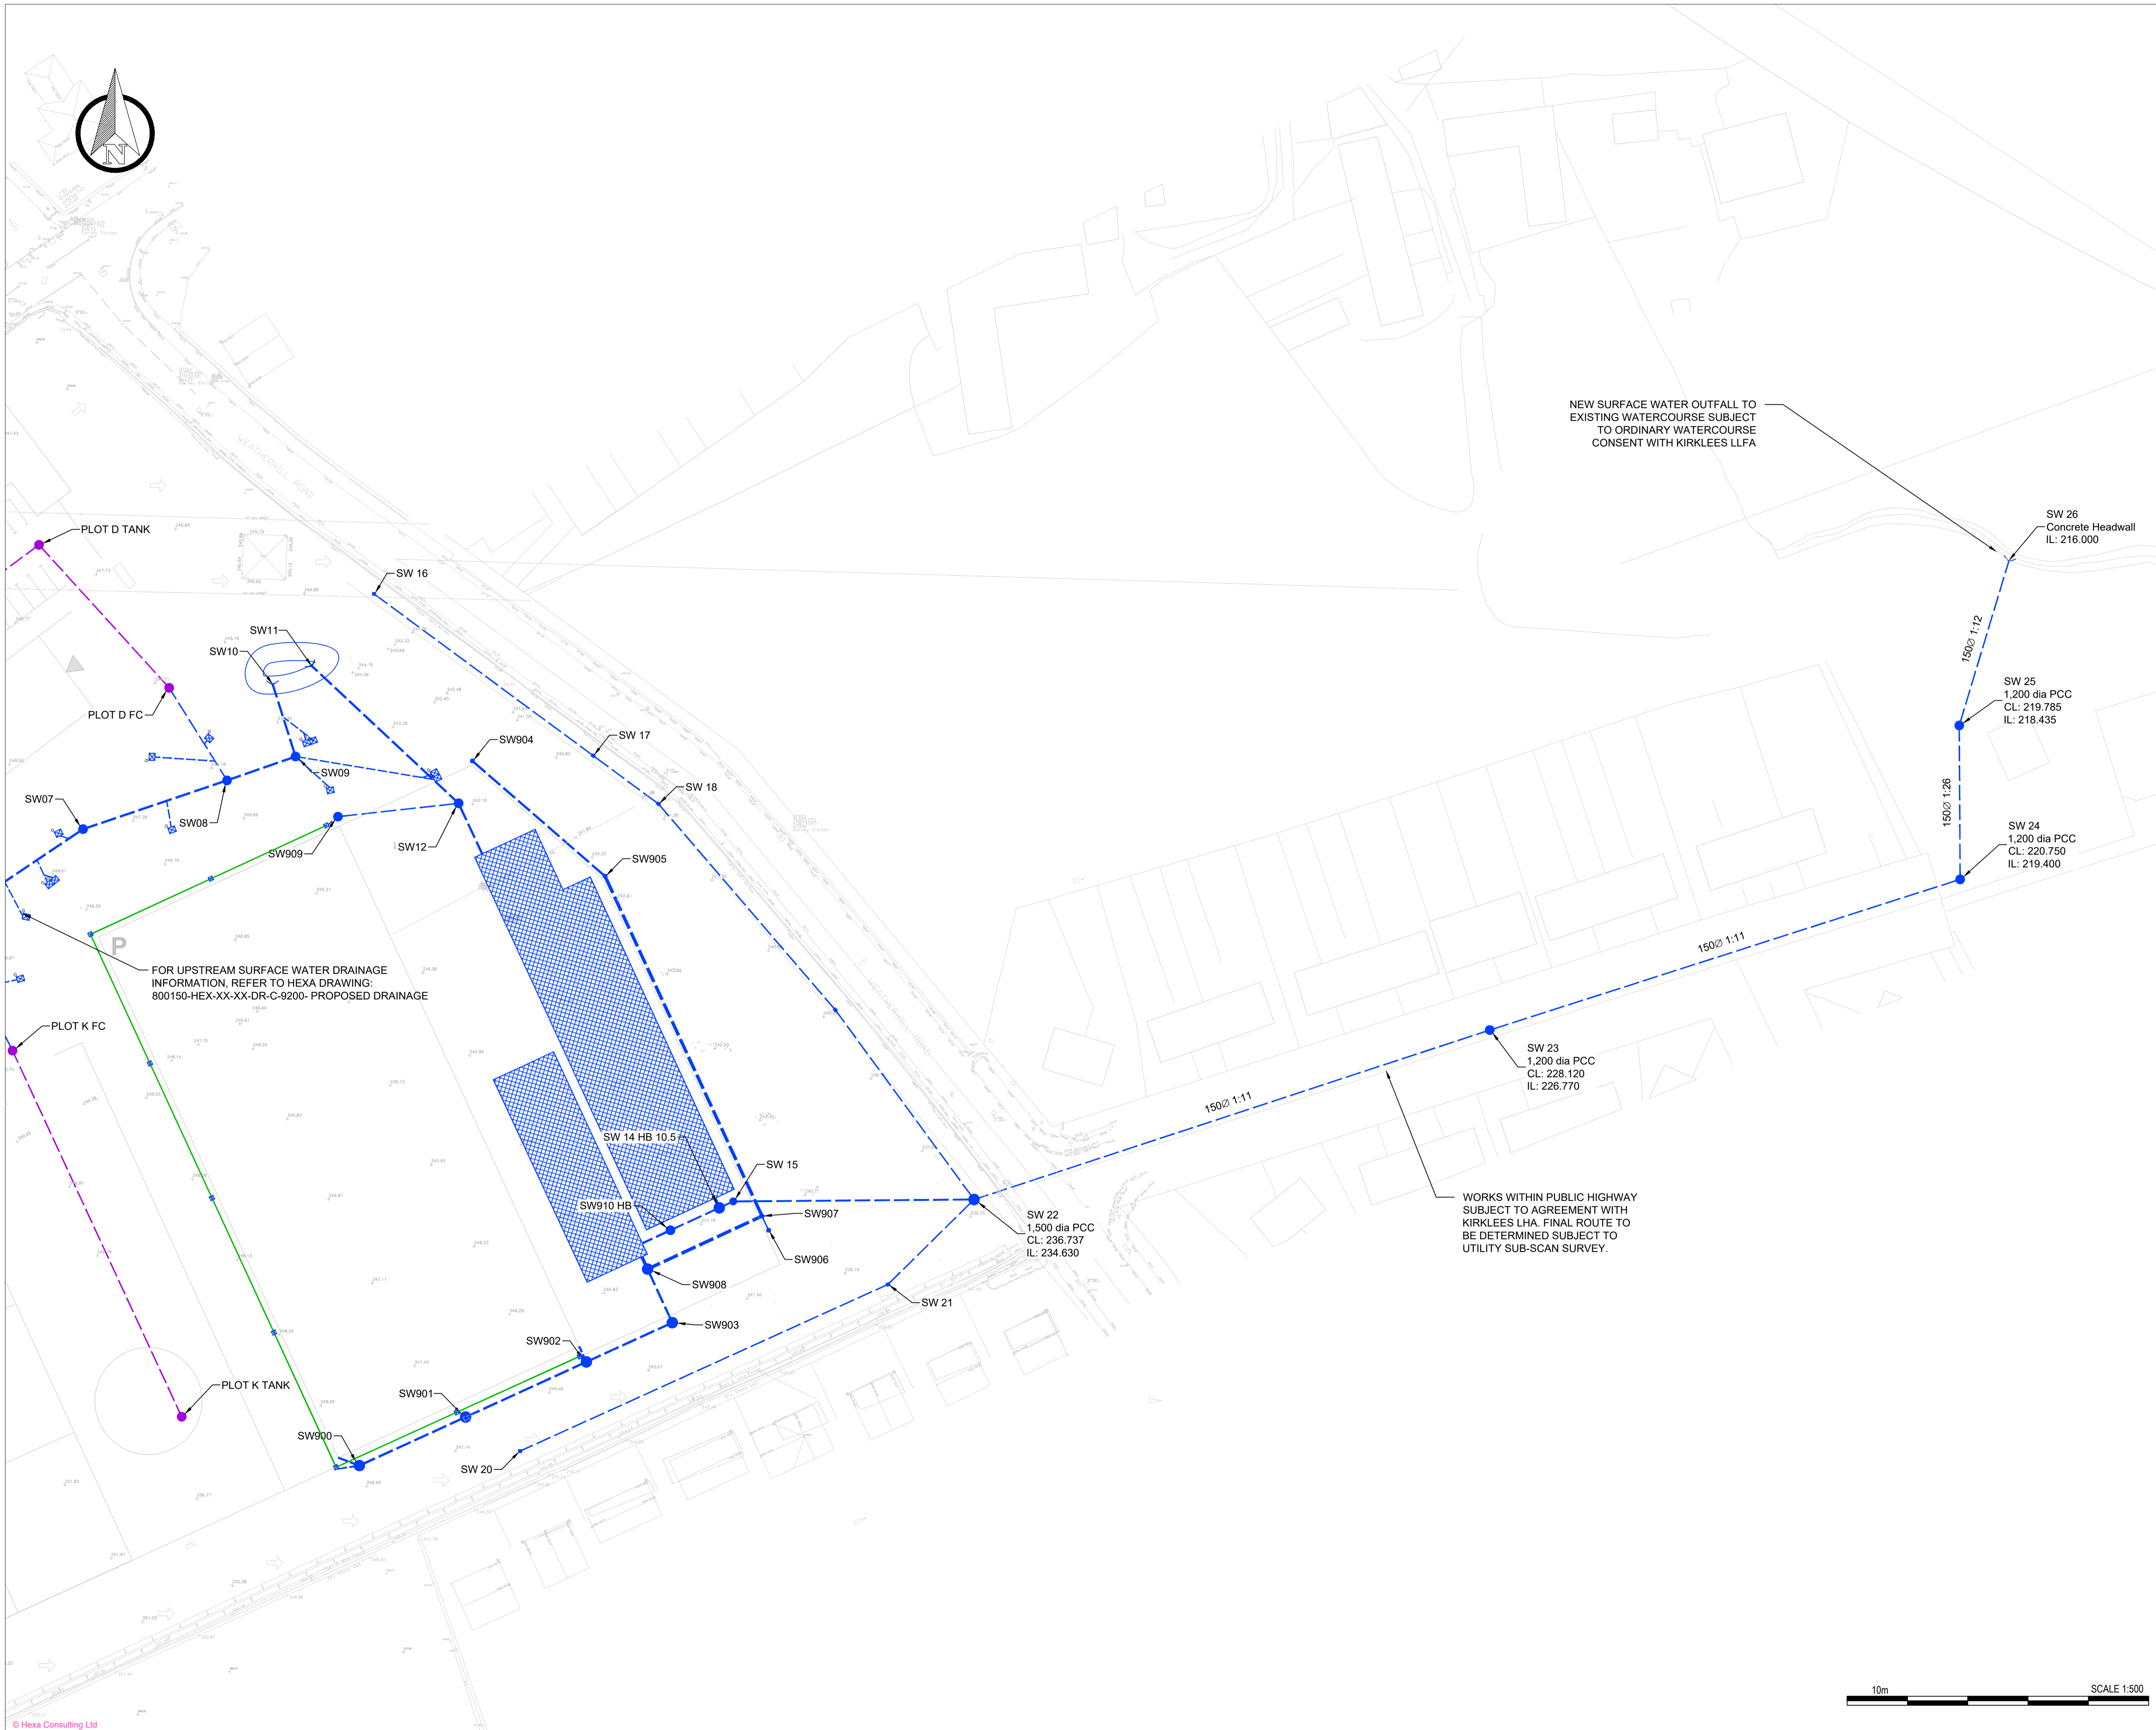

P01	08.05.26	INITIAL ISSUE	SM	KJ
Rev	Date	Details of Issue	Drawn	Rwd

Issues & Revisions

Consultant



Client

MORE CONSTRUCTION

Project Title

LINDLEY MOOR ROAD

Drawing Title

ALTERNATIVE SITE WIDE DRAINAGE LAYOUT OPTION B OUTFALL

Drawn By	SM	Reviewed By	KJ
Hexa Ref	800150	Scale at A1	1:500

Purpose of Issue	Status
PRELIMINARY	S1

Project - Originator - Zone - Level - Type - Role - Number	Revision
800150-HEX-XX-XX-DR-C-9201	P01

