
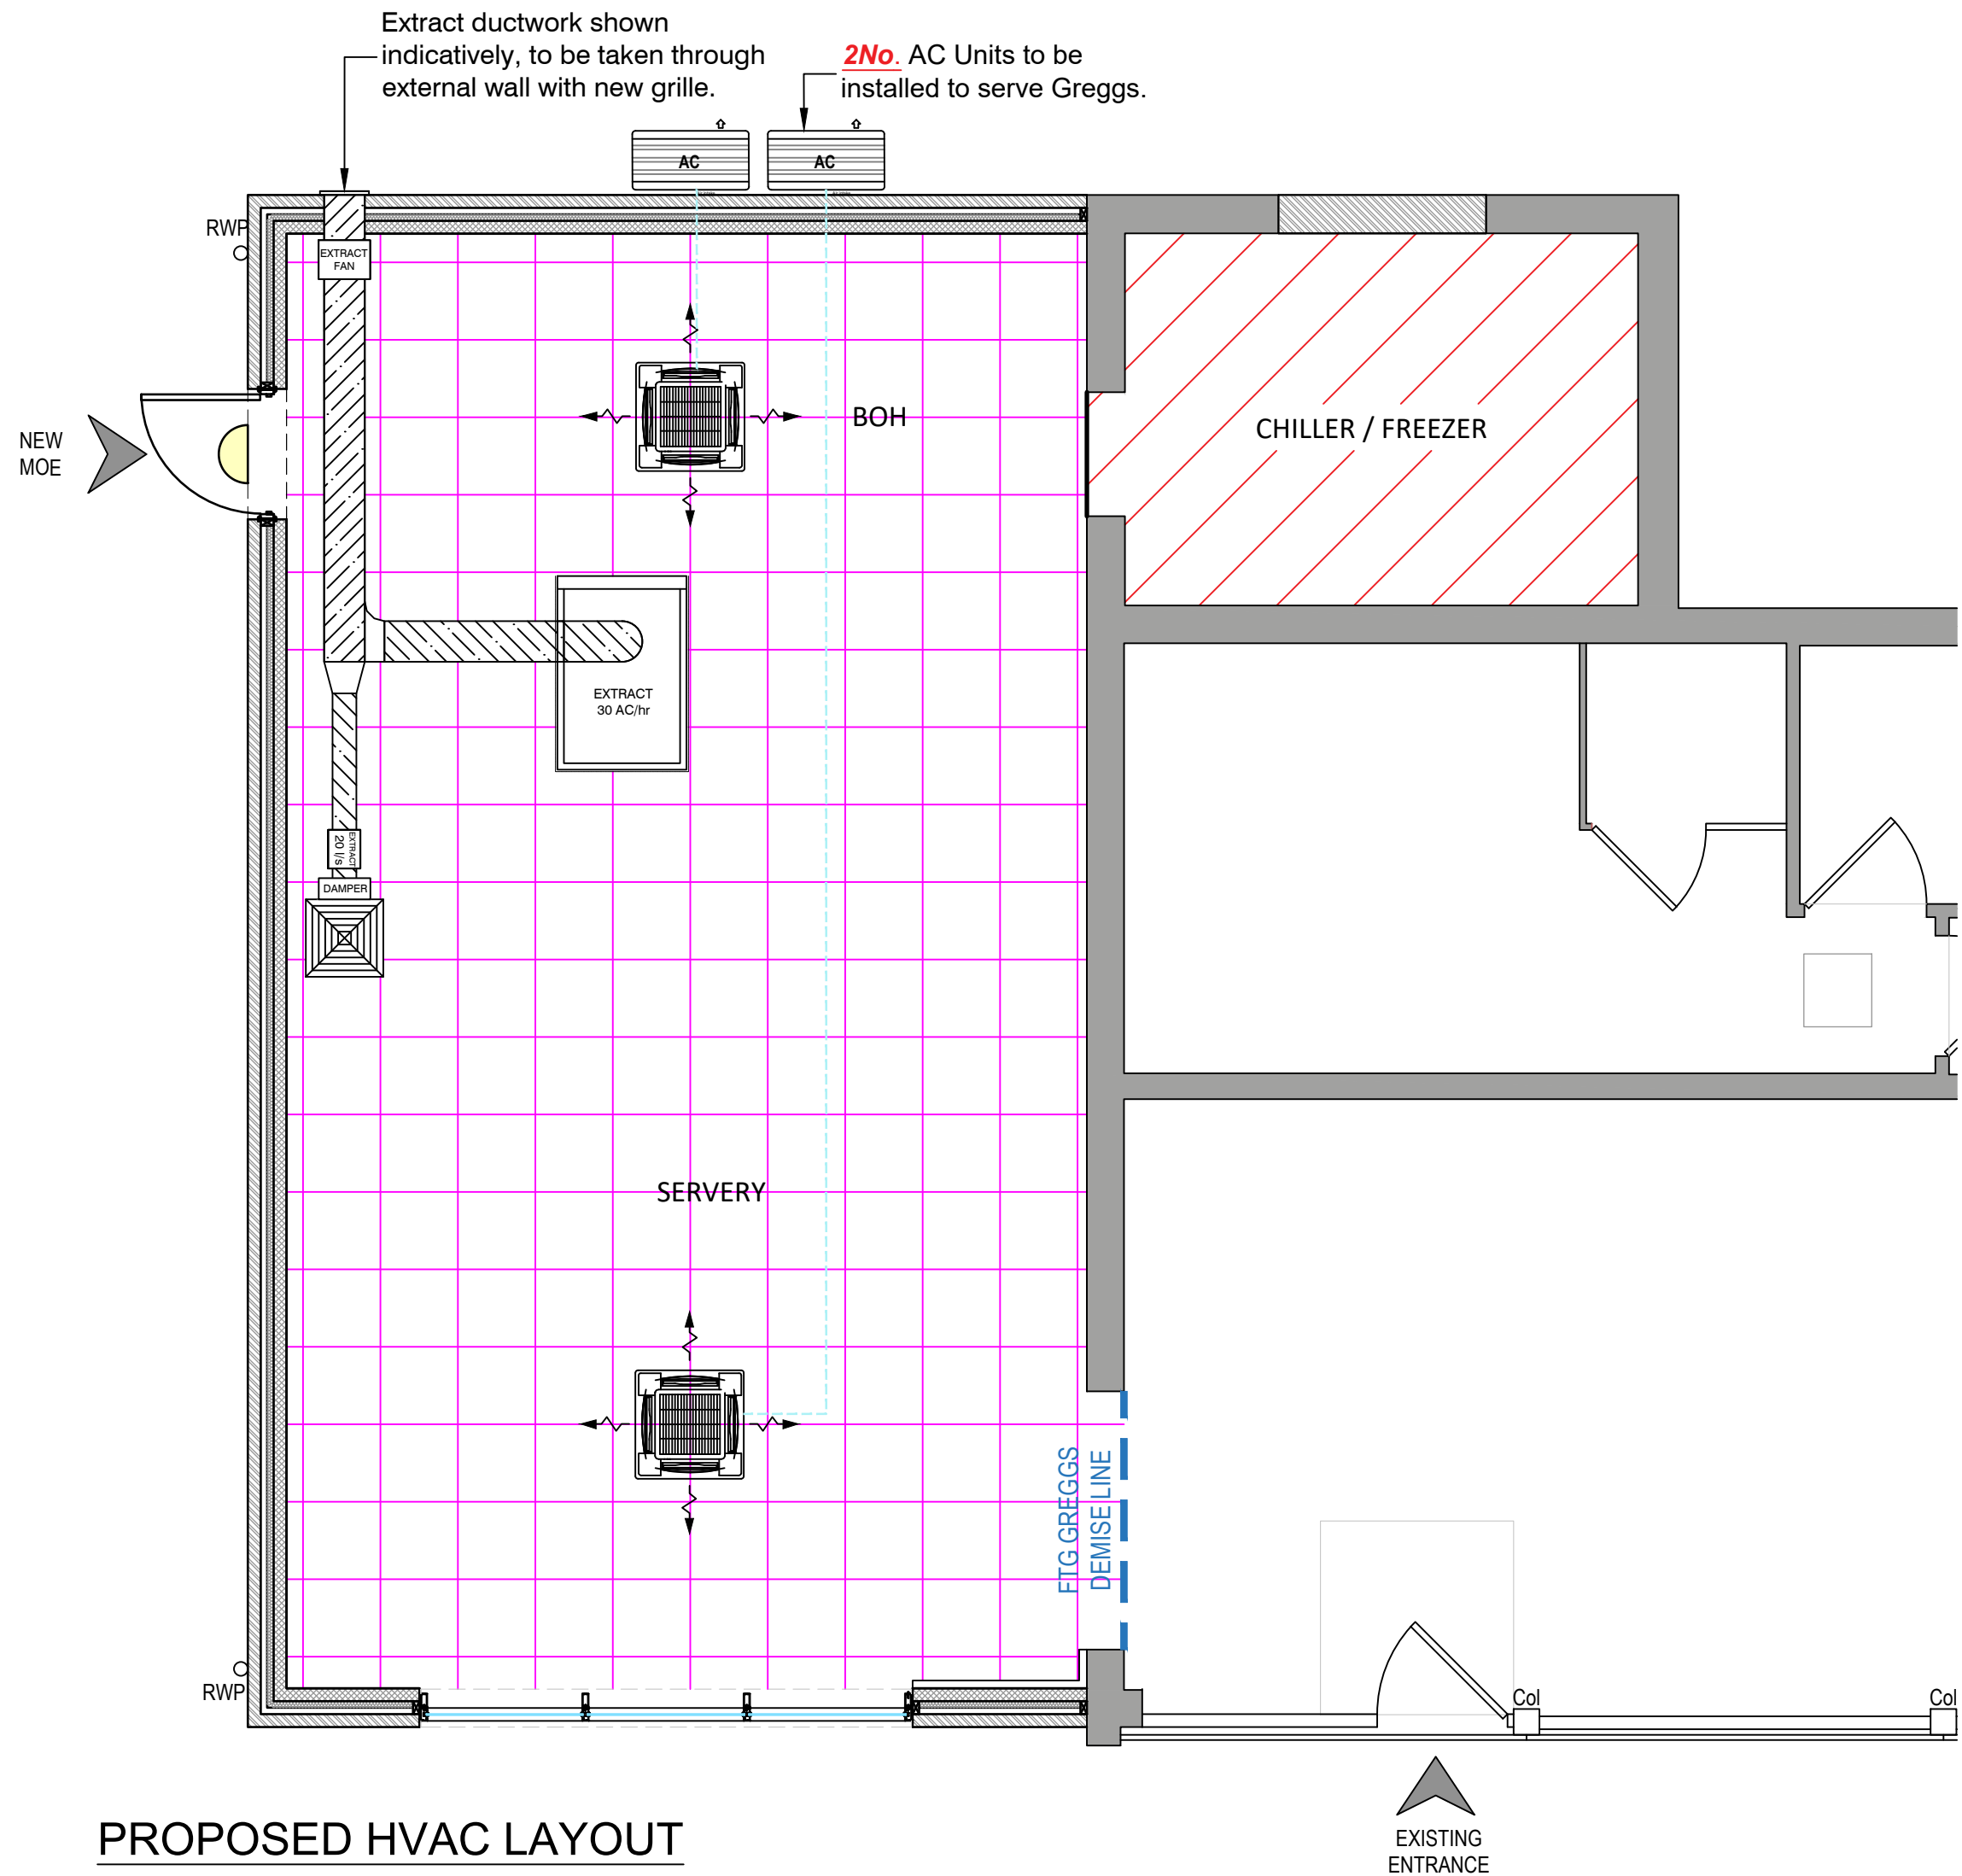


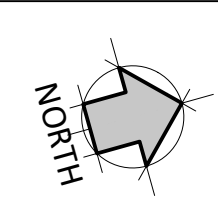

PROPOSED HVAC LAYOUT
SCALE - 1:50

VENTILATION SPECIFICATION				
ITEM	LOCATION	MAKE	MODEL	COOLING CAPACITY (kW0
FRONT OF HOUSE 4 WAY AC UNIT	Internal Ceiling	Toshiba	RAV-GM1601UTP-E	14KW
FRONT OF HOUSE CONDENSOR UNIT	External	Toshiba	RAV-GM1602ATW-E	-
BACK OF HOUSE 4 WAY AC UNIT	Internal Ceiling	Toshiba	RAV-GM902UTP-E	8KW
BACK OF HOUSE CONDENSOR UNIT	External	Toshiba	RAV-GM902ATW-E	-
EXTRACT FAN	Internal Ceiling	ETALINE	EL250 E2 01	-

DRAWING NOTES

COPYRIGHT ©
This drawing and the details herein are the copyright of MBH Design Studio Ltd. and must not be reproduced, altered or passed to any third party without prior written consent.

This drawing has been produced for the project listed below, is submitted in support of this application application to the Local Planning Authority and is not intended for use by any other person or for any other purpose.

Every effort has been made to ensure the accuracy of these drawings, however MBH Design Studio Ltd. accept no responsibility for any discrepancies arising from the reuse of survey information and preliminary drawings commissioned by the Applicant from others.

GENERAL NOTES

- This drawing has been prepared for the sole purpose of obtaining planning permission.
- This drawing is to be read in conjunction with drawings numbered:

13539-670-1P

13539-670-BP

13539-670-20

13539-670-20-1

13539-670-21

13539-670-21-1

13539-670-22

13539-670-23

13539-670-24

13539-670-24-1

13539-670-25

13539-670-26

13539-670-27

13539-670-28

13539-670-29

13539-670-210

13539-670-211

13539-670-212

Location Plan

Block Plan

Existing Site Plan

Existing Site Elevations

Proposed Site Plan

Proposed Site Elevations

Existing Sales Building Layout

Existing Sales Building Elevations

Proposed Sales Building

Proposed HVAC Layout

Proposed Sales Building Elevations

Substation Enclosure Details

LV Enclosure Details

Meter Cabinet Details

Jet Wash Plan and Elevations

Air/Water and Vac Details

Plant Room Elevations

Alpitronic Details
- Any advertisements are indicative and are subject to a separate advertisement application
- Any neighbouring buildings shown on the elevations are diagrammatic and have been extrapolated from site photographs. They have not been measured.

SCHEDULE OF PROPOSED FINISHES

BUILDING EXTERNAL WALLS
Blockwork to match existing external wall finish.

BUILDING ROOF
Existing sales building pitched roof to be retained. New flat roof to be installed over proposed extension.

SHOPFRONT
Part New Shopfront frames to be finished in Grey (RAL7016)
Existing fully glazed, single auto-sliding door, frames to be finished in Grey (RAL 7016)

CANOPY
Traditional steel framed canopy over forecourt w/o signage fascia.

SURFACING
Mixture of concrete and Asphalt, with various drainage channels / gullies.

BIN STORE
Proposed new bin store (2.4m high)

0

1

2

3

4

5

SCALE - METRES - 1:50

REV	DATE	DESCRIPTION	DRN/CHD/APPD
REVISION NOTES			
PLANNING			
mbh MBH Design Studio Ltd. Brook House, Apex Court,Camphill Rd, West Byfleet, Surrey, KT14 6SQ www.mbhstd.com t: 01932 352 727 f: 01932 351 545			
CLIENT			
mfg motor fuel group			
PROJECT			
FS670 SALENDINE SERVICE STATION NEW HEY ROAD, HUDDERSFIELD, WEST YORKSHIRE HD3 3UZ			
DRAWING TITLE			
PROPOSED HVAC LAYOUT			
DRAWN BY	DATE	SCALE	PAPER SIZE
HP	19.03.2026	1:50	A1
CHECKED / APPROVED BY	DRAWING NUMBER	REV.	
JN/JN	13539-670-24	-	