




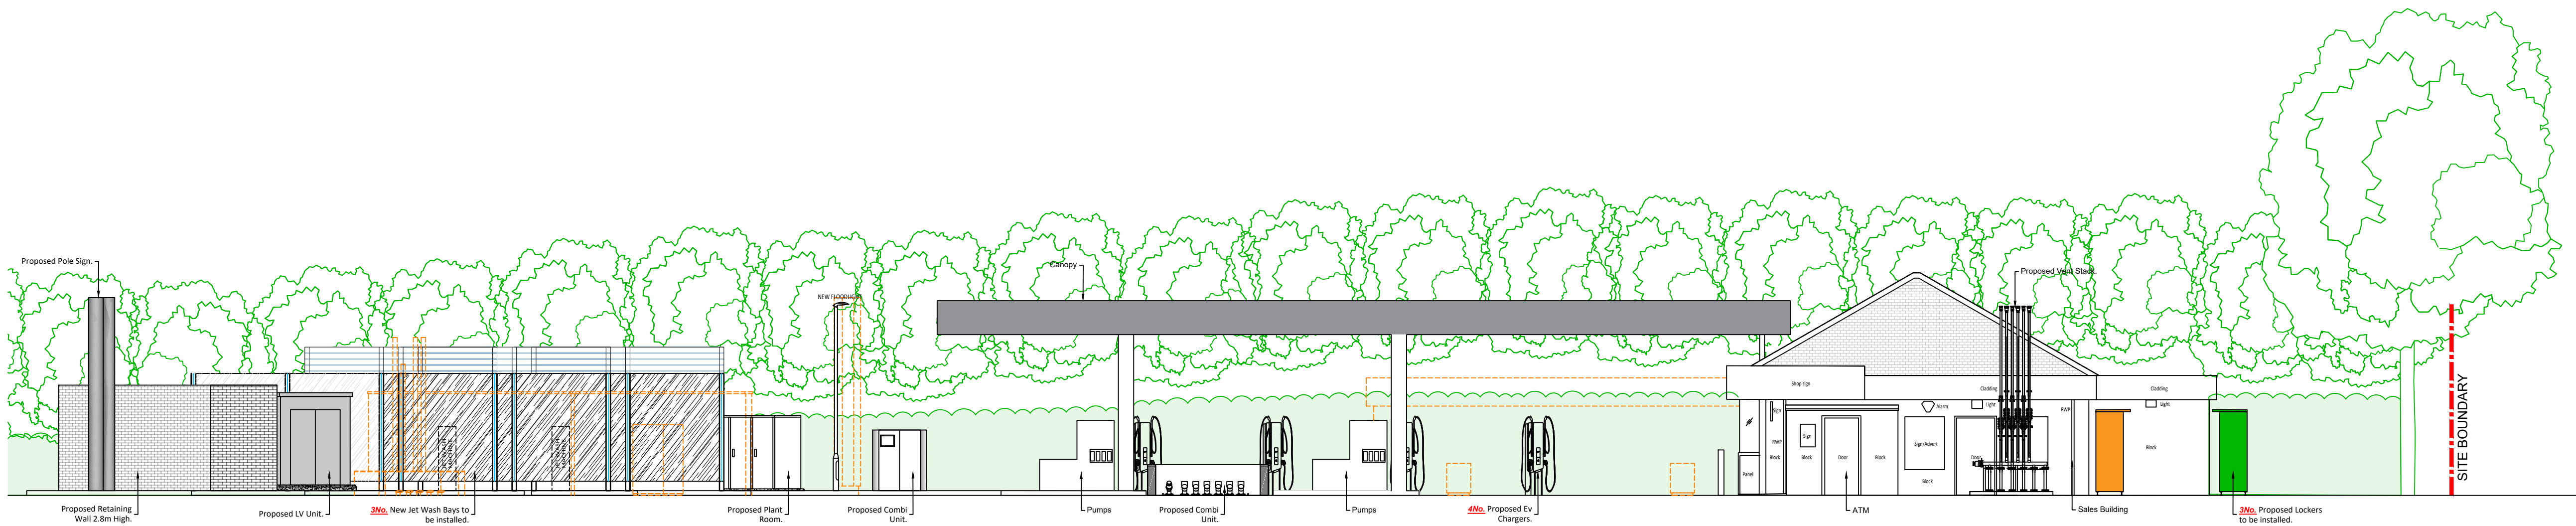


EXISTING SITE ELEVATION-A
SCALE: 1:100

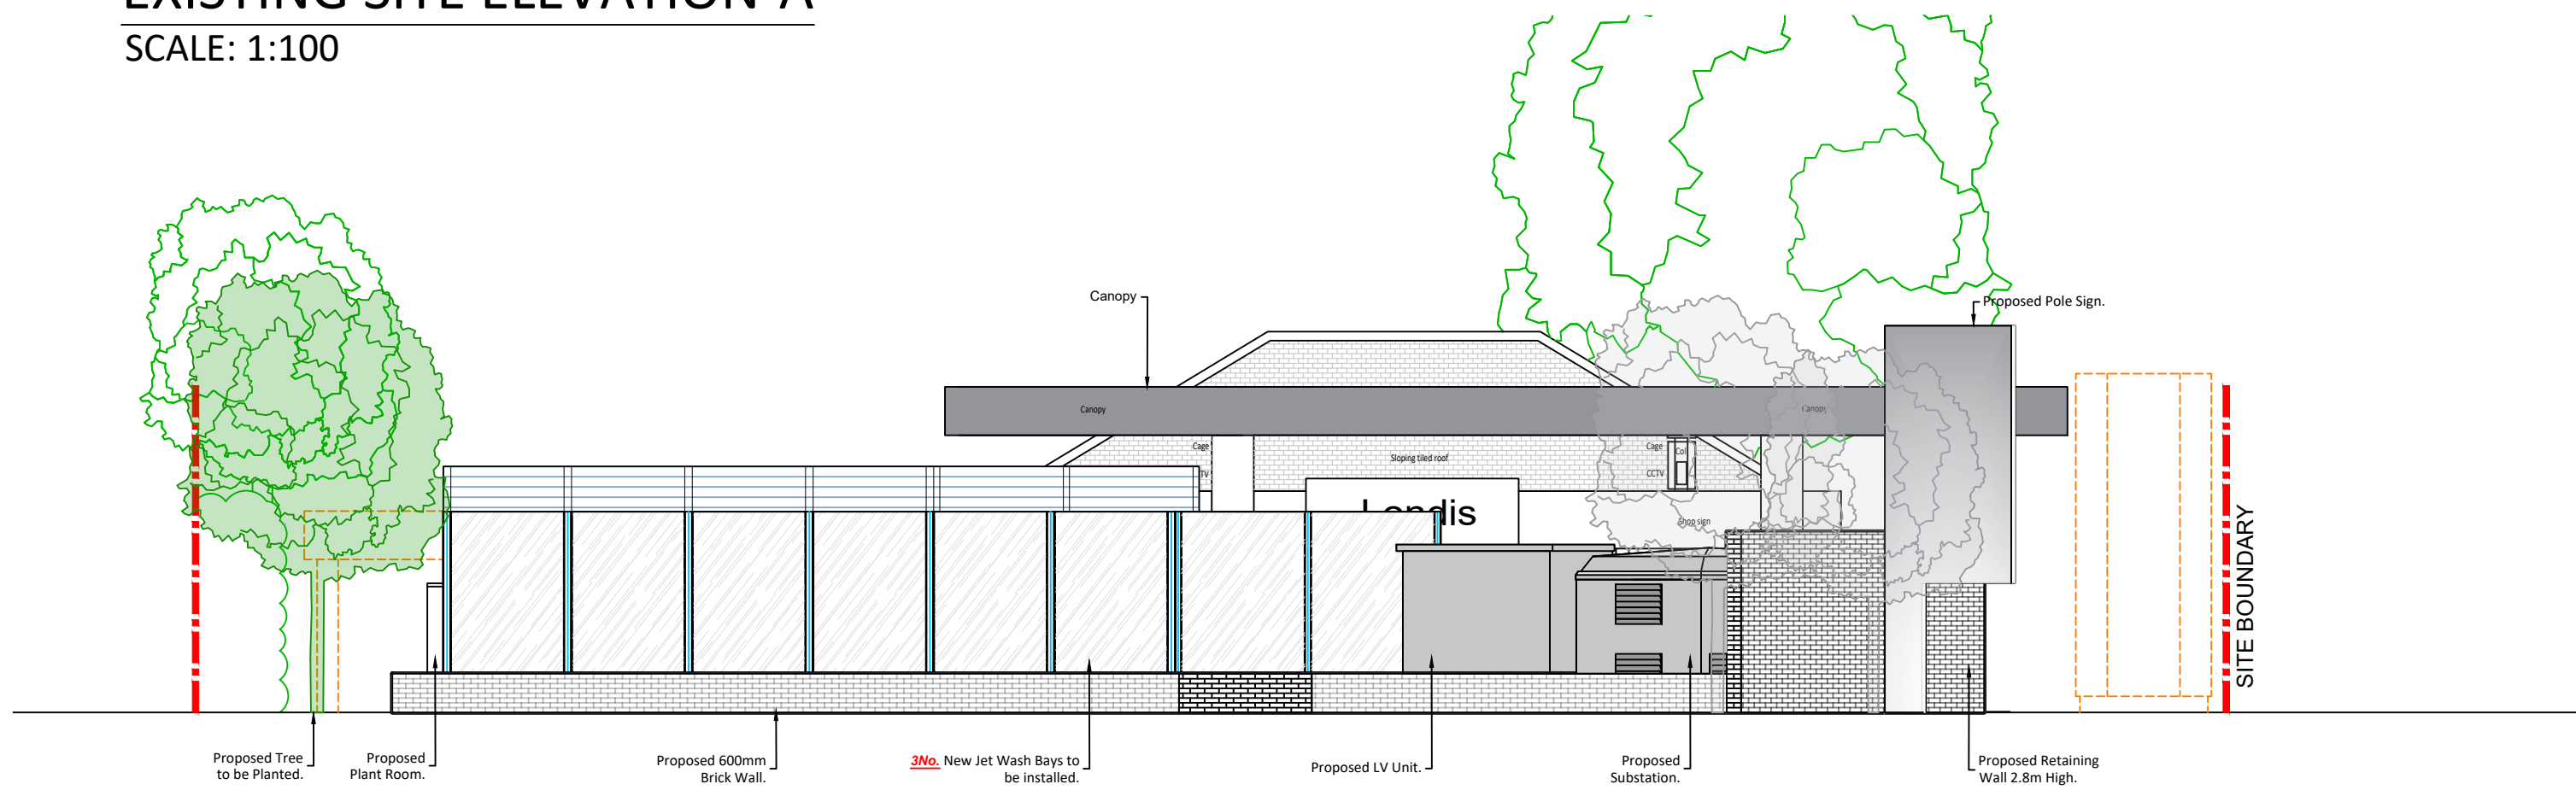


EXISTING SITE ELEVATION-B
SCALE: 1:100

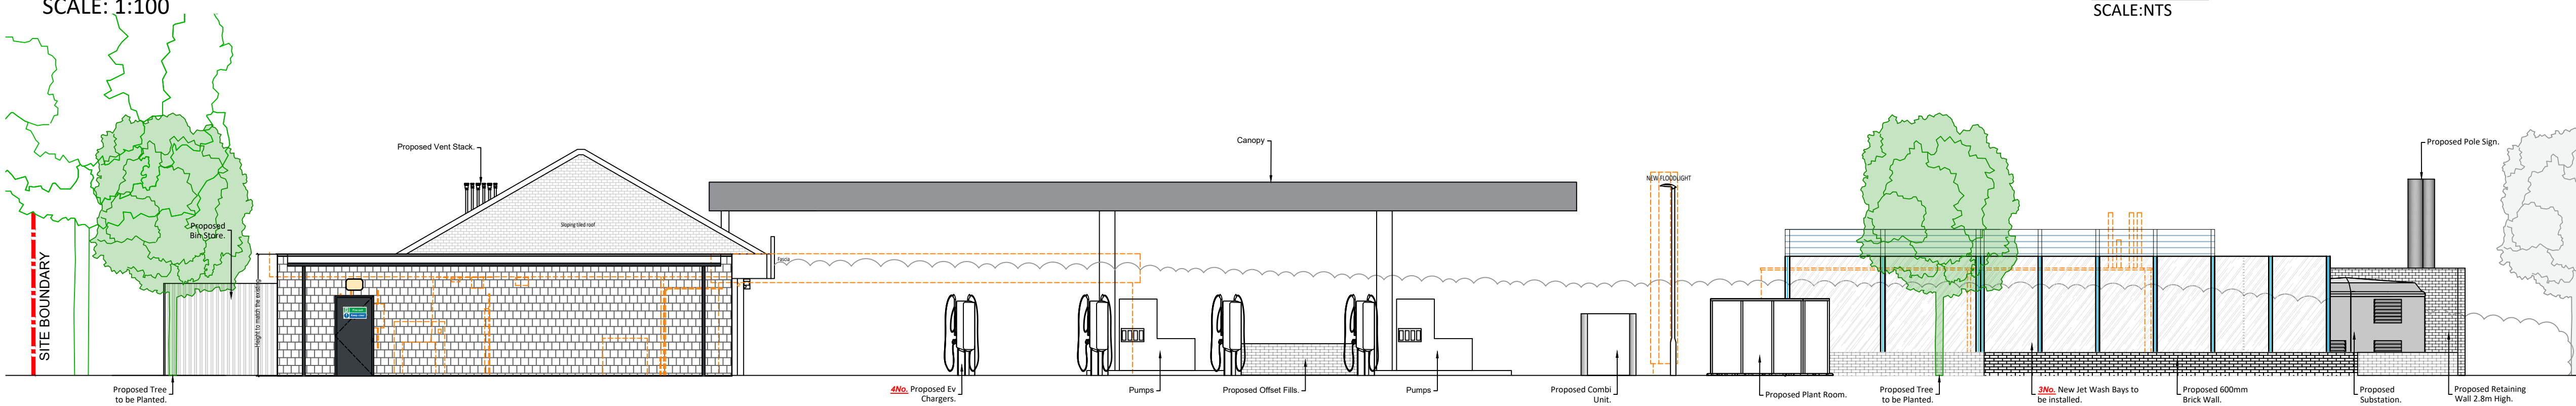

EXISTING SITE ELEVATION-C
SCALE: 1:100

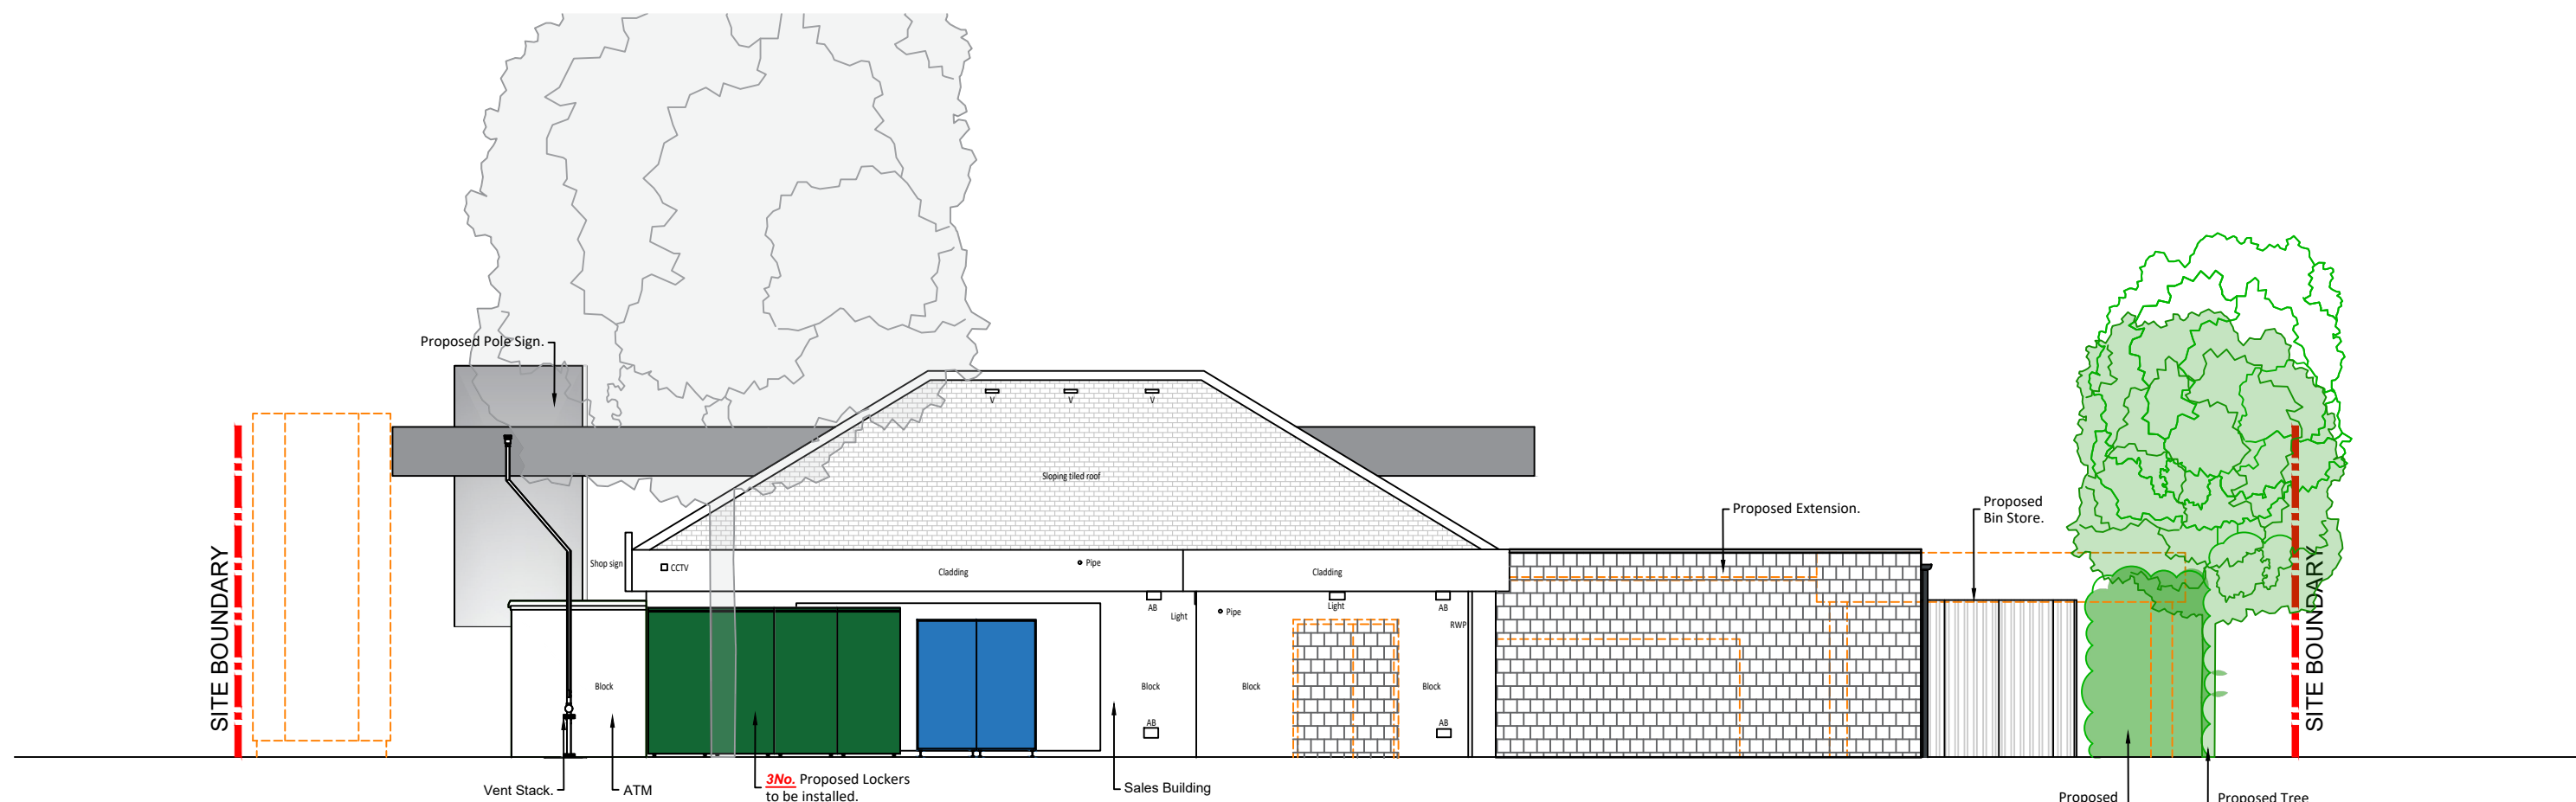

EXISTING SITE ELEVATION-D
SCALE: 1:100

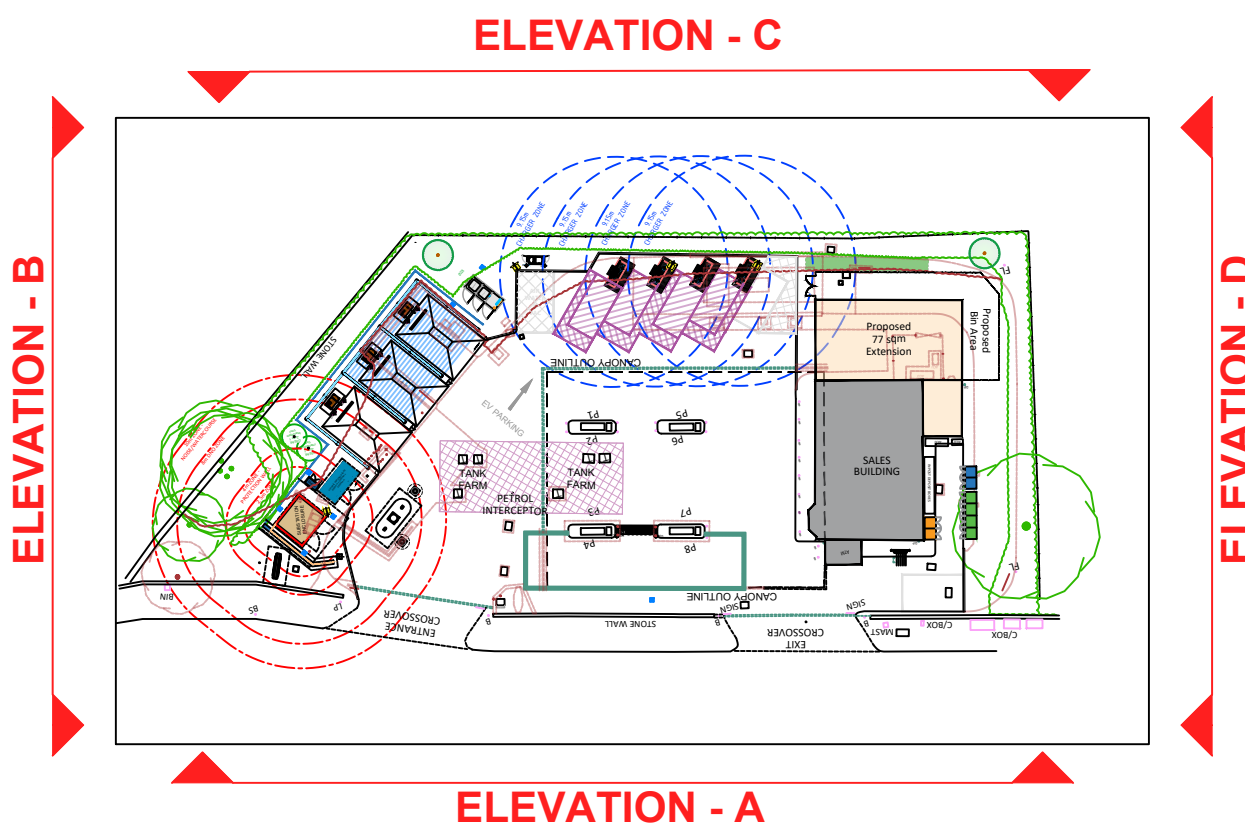

KEY PLAN
SCALE:NTS

DRAWING NOTES

COPYRIGHT ©
This drawing and the details herein are the copyright of MBH Design Studio Ltd. and must not be reproduced, altered or passed to any third party without prior written consent.

This drawing has been produced for the project listed below, is submitted in support of this application application to the Local Planning Authority and is not intended for use by any other person or for any other purpose.

Every effort has been made to ensure the accuracy of these drawings, however MBH Design Studio Ltd. accept no responsibility for any discrepancies arising from the reuse of survey information and preliminary drawings commissioned by the Applicant from others.

- GENERAL NOTES**
- This drawing has been prepared for the sole purpose of obtaining planning permission.
 - This drawing is to be read in conjunction with drawings numbered:
 - 13539-670-LP Location Plan
 - 13539-670-BP Block Plan
 - 13539-670-20 Existing Site Plan
 - 13539-670-20-1 Existing Site Elevations
 - 13539-670-21 Proposed Site Plan
 - 13539-670-21-1 Proposed Site Elevations
 - 13539-670-22 Existing Sales Building Layout
 - 13539-670-23 Existing Sales Building Elevations
 - 13539-670-24 Proposed Sales Building
 - 13539-670-24-1 Proposed HVAC Layout
 - 13539-670-25 Proposed Sales Building Elevations
 - 13539-670-26 Substation Enclosure Details
 - 13539-670-27 LV Enclosure Details
 - 13539-670-28 Meter Cabinet Details
 - 13539-670-29 Jet Wash Plan and Elevations
 - 13539-670-210 Air/Water and Vac Details
 - 13539-670-211 Plant Room Elevations
 - 13539-670-212 Alpitronic Details
 - Any advertisements are indicative and are subject to a separate advertisement application
 - Any neighbouring buildings shown on the elevations are diagrammatic and have been extrapolated from site photographs. They have not been measured.

SCHEDULE OF PROPOSED FINISHES

BUILDING EXTERNAL WALLS
Blockwork to match existing external wall finish.

BUILDING ROOF
Existing sales building pitched roof to be retained. New flat roof to be installed over proposed extension.

SHOPFRONT
Part New Shopfront frames to be finished in Grey (RAL7016)
Existing fully glazed, single auto-sliding door, frames to be finished in Grey (RAL7016)

CANOPY
Traditional steel framed canopy over forecourt w/o signage fascia.

SURFACING
Mixture of concrete and Asphalt, with various drainage channels / gullies.

BIN STORE
Proposed new bin store (2.4m high)

0 5 10
SCALE - METRES -1:100

REV	DATE	DESCRIPTION	DRN/CHD/APPD
REVISION NOTES			

PLANNING

mbh

MBH Design Studio Ltd.
Brook House, Apex Court, Camphill Rd, West Byfleet, Surrey, KT14 6SQ.
www.mbhstd.com t: 01932 352 727 f: 01932 351 545

CLIENT

mfg
motor fuel group

PROJECT

FS670 SALENDINE SERVICE STATION
NEW HEY ROAD,
HUDDERSFIELD, WEST YORKSHIRE
HD3 3UZ

DRAWING TITLE

PROPOSED SITE ELEVATIONS

DRAWN BY	DATE	SCALE	PAPER SIZE
HP	26.06.2026	1:100	A1
CHECKED / APPROVED BY	DRAWING NUMBER	REV.	
HP/NS	13539-670-21-1	-	