


Layout Block Plan
Scale 1:200

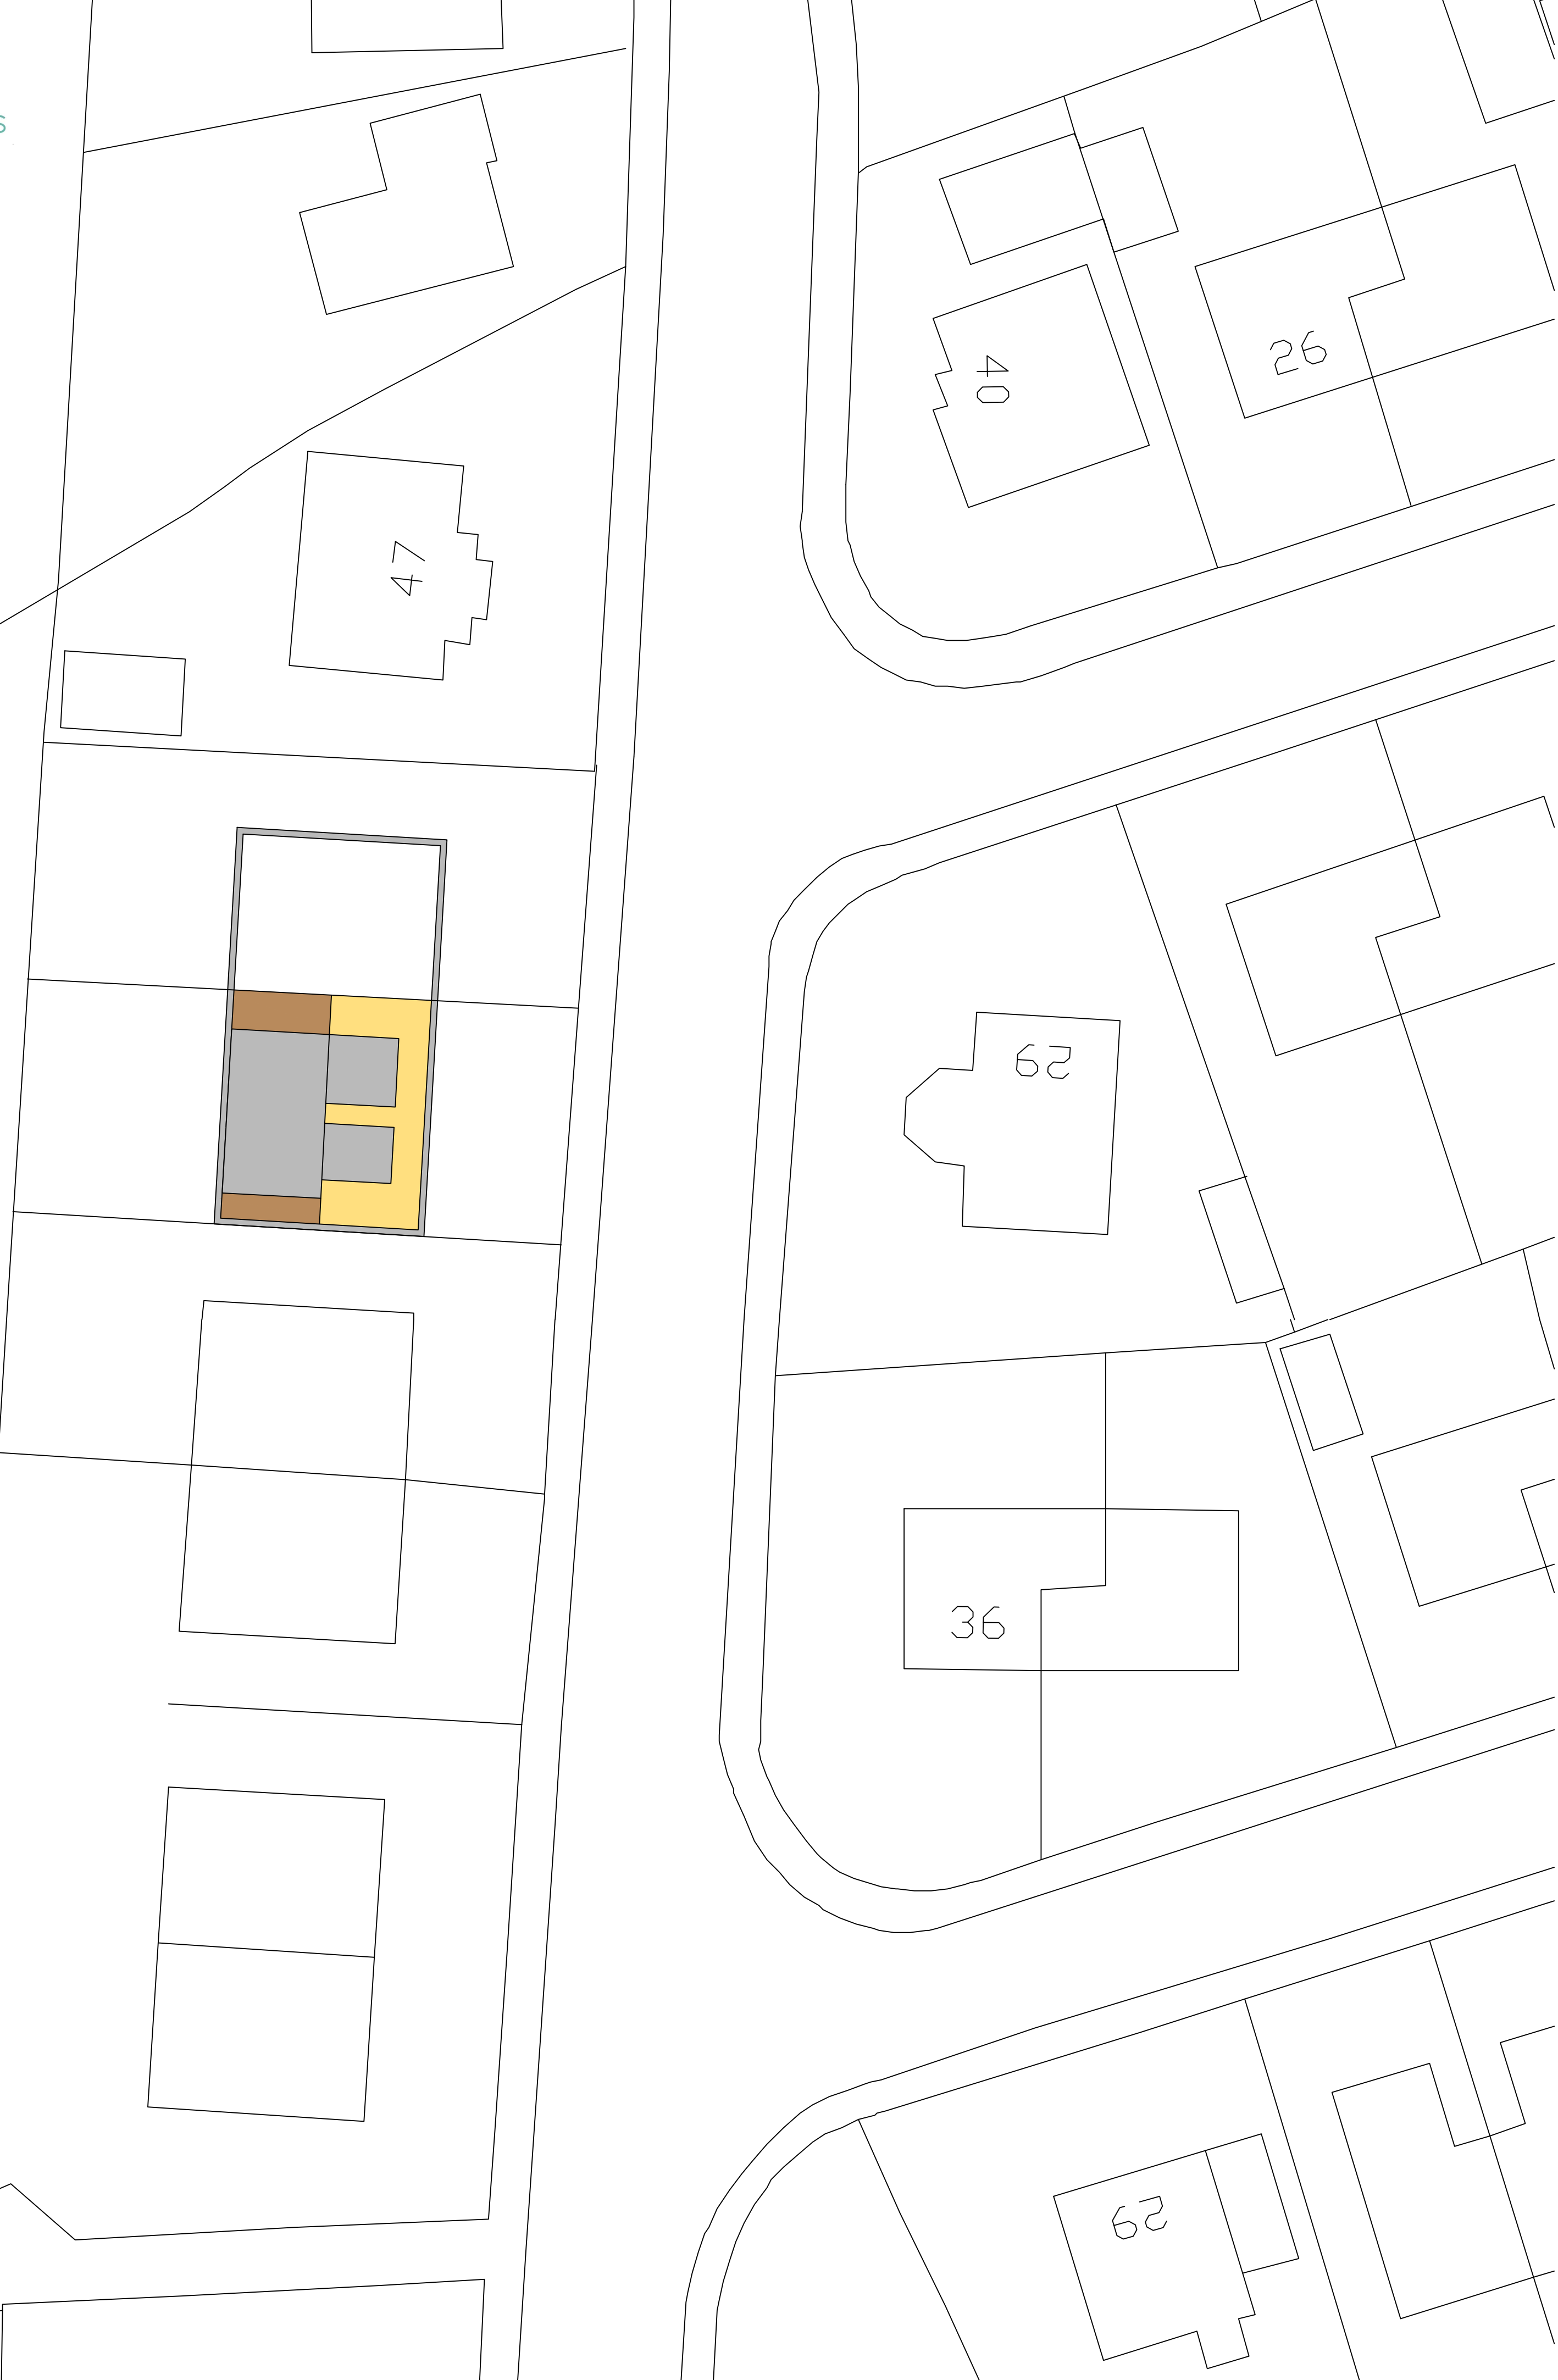

Location Plan
Scale 1:1250

All drawings are to be read in conjunction with specification and all other drawings that relate to this house type.

All notes refer to all drawings of this house type.

Electrical layout is schematic - Completed installation to comply with I.E.E regs & all relevant codes of practices.

Electrical components fit to comply with approved part M.

Do not scale this drawing for construction purposes. *Brightline Design* to be notified of any discrepancies

Verify relevant dimensions on site before commencing work or preperation shop drawings. This Drawing is copyright.

Client
Jonathan Lendon

Project
43, Arthur Street, Golcar,
Huddersfield, HD7 4DF

Drawing
Layout and Location Plan

Scale 1:200/1250@A1	Date JUL26	Drawn R.FOSTER
Drawing No. 26-022-03	Checked by J.WHIP	Revision -

